



Comhairle Chontae Na Mí
Meath County Council

CARNAROSS SEWERAGE SCHEME
OUTFALL LICENCE APPLICATION

4654/OL/06/00	Schedule of Drawings
4654/OL/06/01	Attachment A.1 - Site Location Map
4654/OL/06/02	Attachment B.1 - Agglomeration Outline Plan
4654/OL/06/03	Attachment B.2 - Existing Waste Water Treatment Facilities - Overall Site Plan
4654/OL/06/04	Attachment B.3 - Existing Primary Discharge Point
4654/OL/06/05	Attachment C.1 - Existing Waste Water Treatment Facilities - Layout Plan
4654/OL/06/06	Attachment F.1 - Designation Map

Notes



1. FIGURED DIMENSIONS ONLY TO BE TAKEN FROM THIS DRAWING
2. ALL DRAWINGS TO BE CHECKED BY THE CONTRACTOR ON SITE.
3. ENGINEER TO BE INFORMED OF ANY DISCREPANCIES BEFORE ANY WORK COMMENCES.

rev.	modifications	by	ds

client			
MEATH COUNTY COUNCIL			
project			
CARNAROSS SEWERAGE SCHEME			
stage			
WASTE WATER DISCHARGE LICENCE APPLICATION			
title			
SCHEDULE OF DRAWINGS			
scales			
N/A			
drawn	checked	approved	date
TC	YMcG	TMcG	Nov. 2009

© COPYRIGHT OF
JENNINGS O'DONOVAN & PARTNERS
CONSULTING ENGINEERS,
FINISKLIN BUSINESS PARK,
SLIGO.
Tel. (071) 9161416.
Fax. (071) 9161080.
Email info@jodireland.com

drawing no.	revision
4654/OL/06/00	

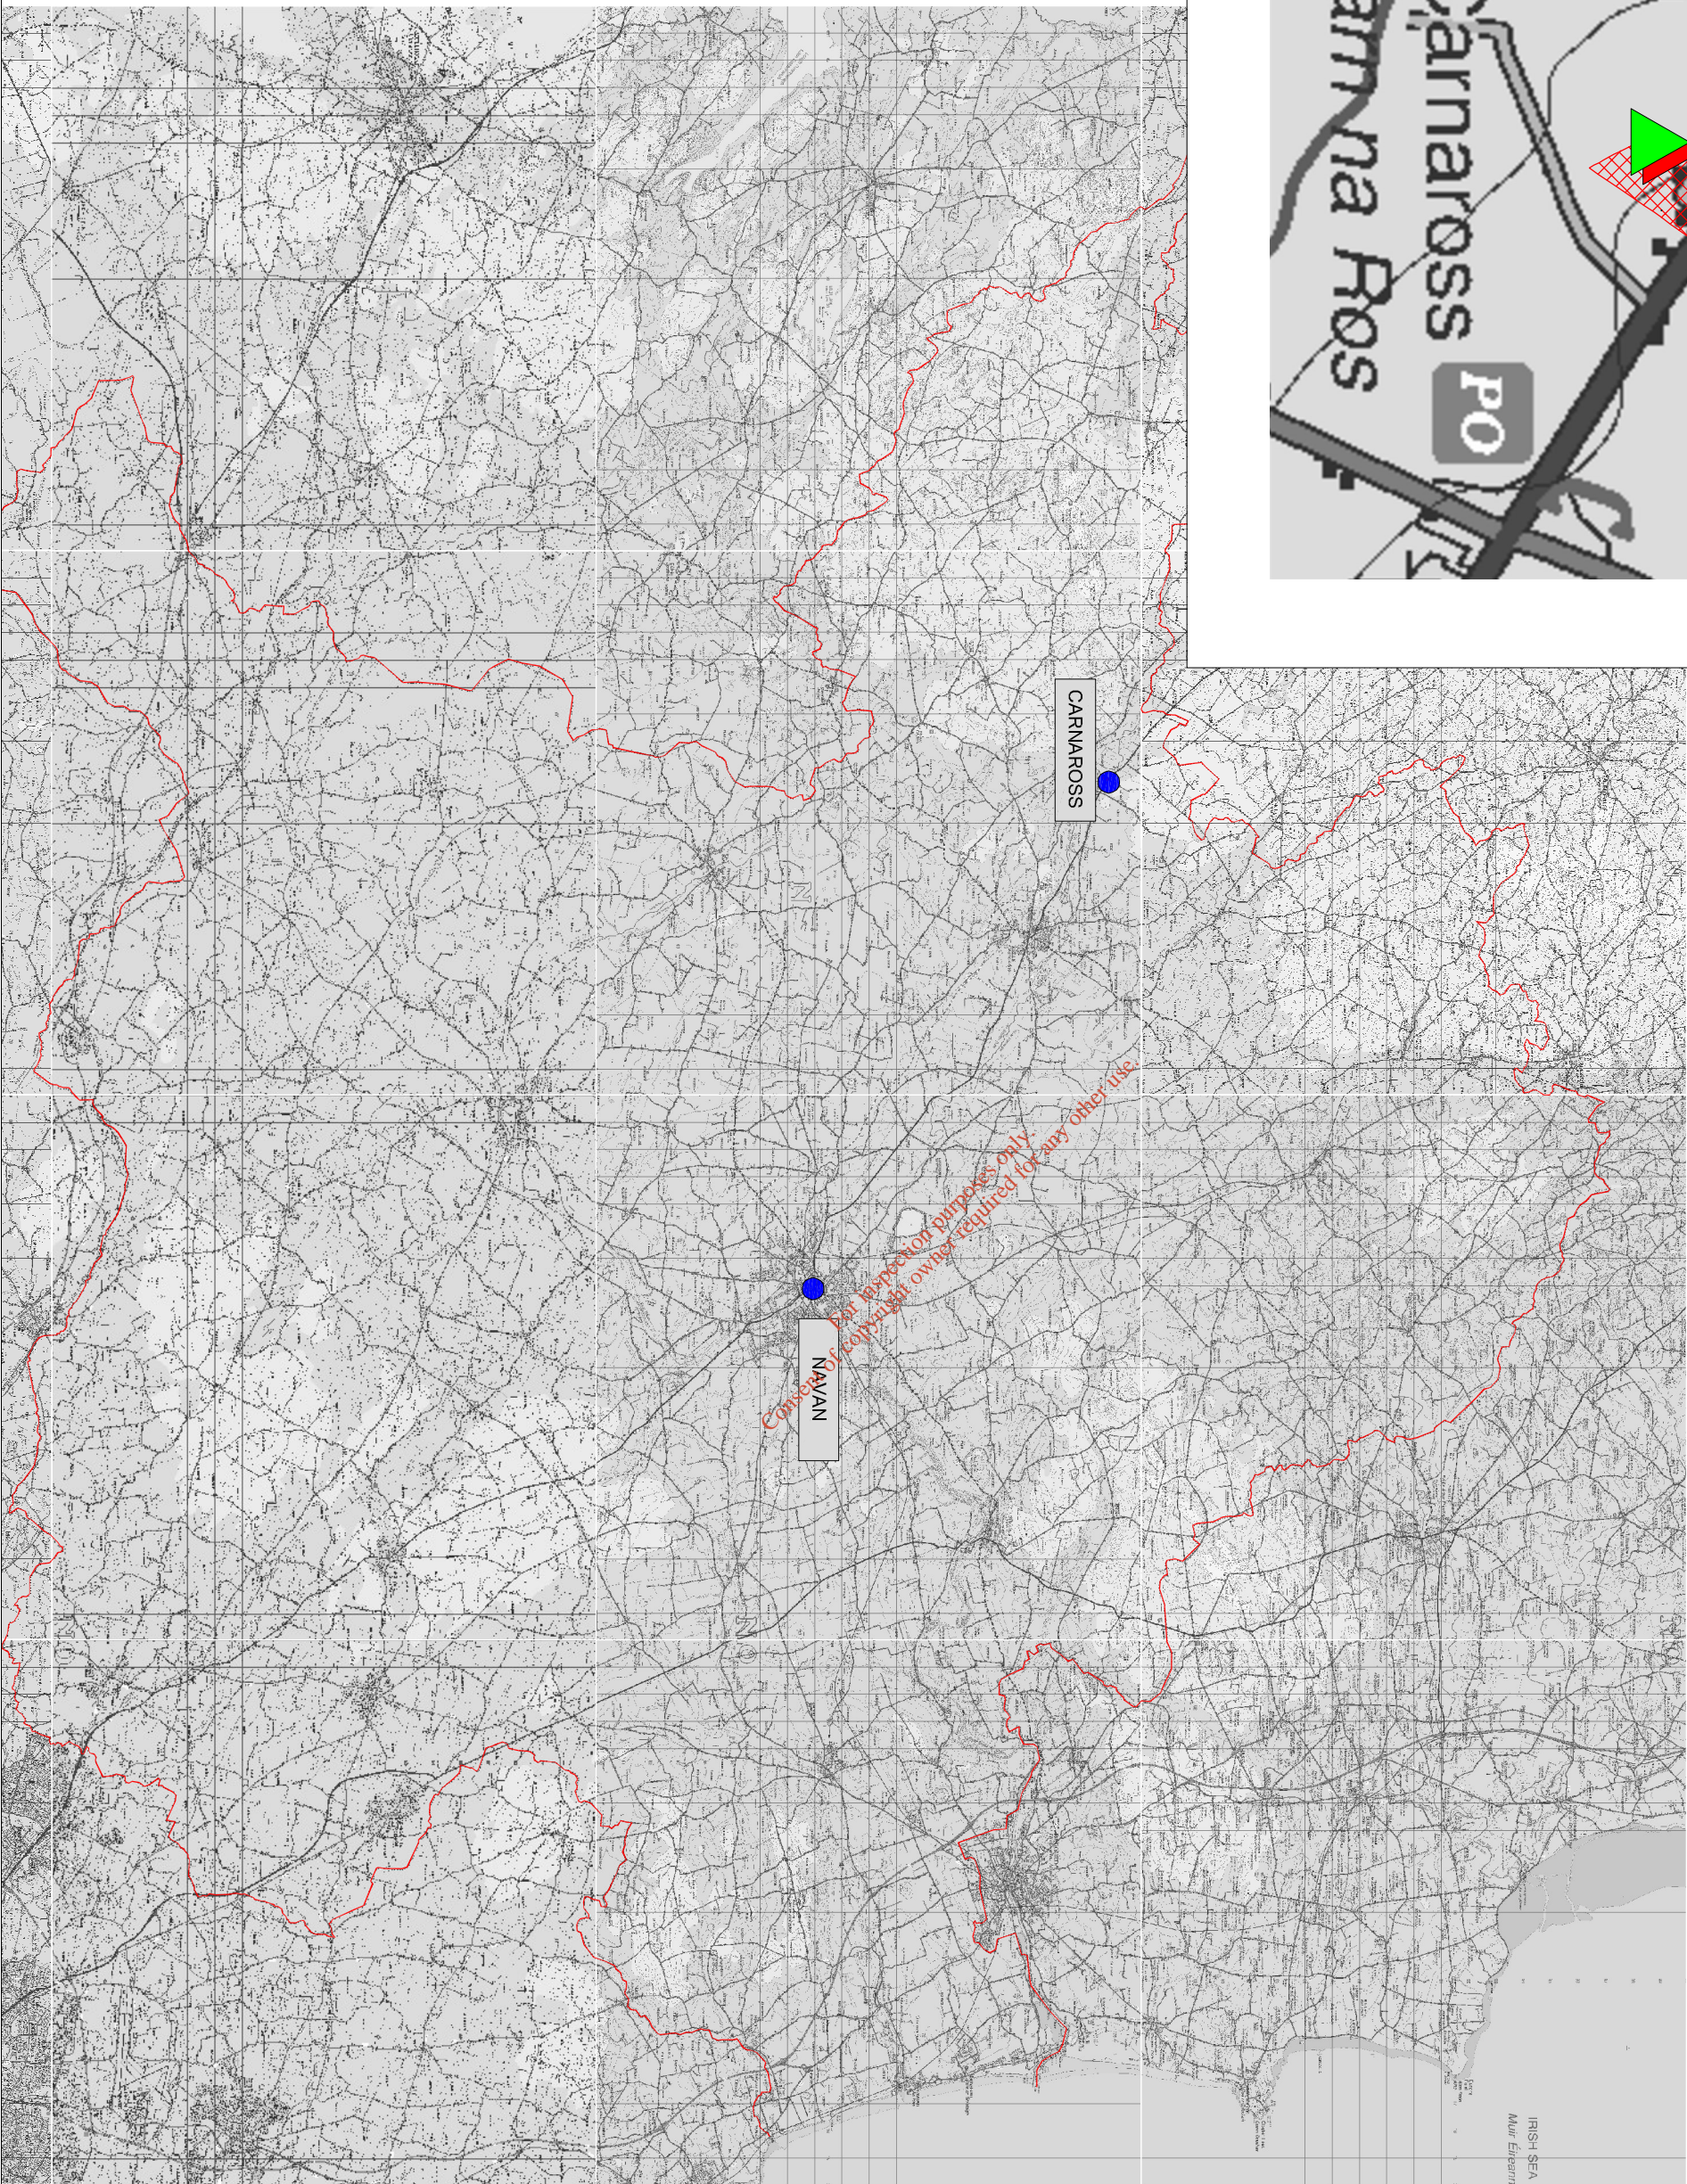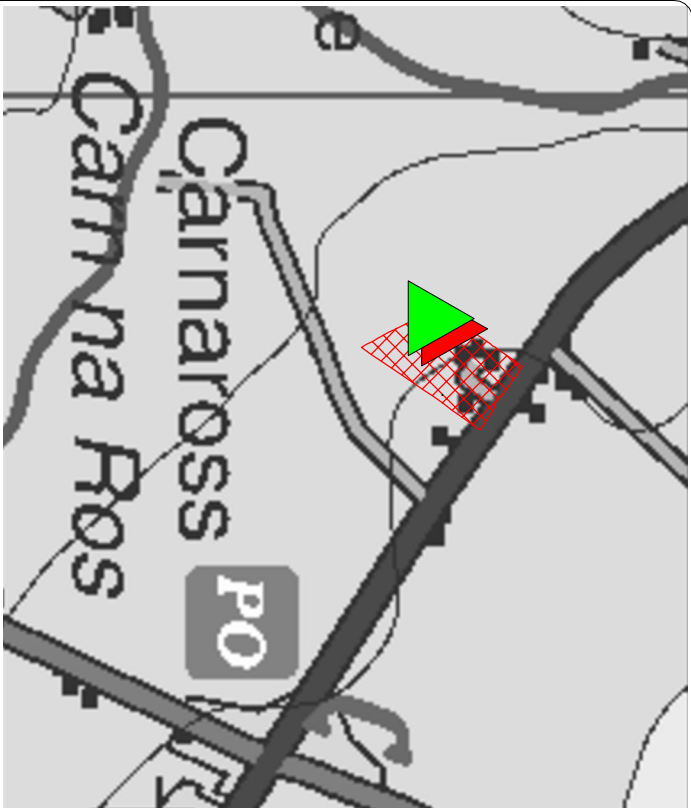

Notes

1. FIGURED DIMENSIONS ONLY TO BE TAKEN FROM THIS DRAWING.
2. ALL DRAWINGS TO BE CHECKED BY THE CONTRACTOR ON SITE.
3. ENGINEER TO BE INFORMED OF ANY DISCREPANCIES BEFORE ANY WORK COMMENCES.

LEGEND:



 AGGLOMERATION CATCHMENT AREA



EXISTING TREATMENT WORKS



EXISTING TREATED EFFLUENT
DISCHARGE POINT

[illegible]

rev.	modifications	by	date
------	---------------	----	------

client

MEATH COUNTY COUNCIL

project

CARNAROSS SEWERAGE SCHEME

stage

WASTE WATER DISCHARGE
LICENCE APPLICATION

title

ATTACHMENT A.1
LOCATION MAP

scales

1 / 10,000 & 250,000

drawn TC	checked YMcG	approved TMcG	date Nov. 2009
----------	--------------	---------------	----------------

© COPYRIGHT OF

JENNINGS O'DONOVAN & PARTNERS
CONSULTING ENGINEERS,
FINISKILIN BUSINESS PARK,
SLIGO.



Email info@jodireland.com

drawing no.

4654/OL/06/01

CARNAROS



EXISTING WASTE WATER TREATMENT WORKS

10KV

91.4





91.0

90.0

Notes

1. FIGURED DIMENSIONS ONLY TO BE TAKEN FROM THIS DRAWING
2. ALL DRAWINGS TO BE CHECKED BY THE CONTRACTOR ON SITE
3. ENGINEER TO BE INFORMED OF ANY DISCREPANCIES BEFORE ANY WORK COMMENCES.

LEGEND :

-  Agglomeration Catchment Area
 Existing Sewers
 Existing Older Sewers
 Existing Works

rev.	modifications	by	da

client

MEATH COUNTY COUNCIL

project

CARNAROSS SEWERAGE SCHEME

stage

WASTE WATER DISCHARGE
LICENCE APPLICATION

title

ATTACHMENT B.1
AGGLOMERATION OUTLINE PLAN

scales

1 / 1,000

drawn
TC

checke
YMcG

Approved
T McG

ate
lov. 2009

© COPYRIGHT OF

JENNINGS O'DONOVAN & PARTNERS
CONSULTING ENGINEERS,
FINISKILIN BUSINESS PARK,
SLIGO.

Tel. (071) 9161416.
Fax. (071) 9161080.
Email info@jodireland.com



drawing no.


4654/OL/06/02

vision

--	--	--	--	--	--	--

REPRODUCED FROM THE ORDNANCE SURVEY OF IRELAND BY PERMISSION OF THE GOVERNMENT LICENSE No. EN 0002609

EPA Export 26-07-2013:17:22:59

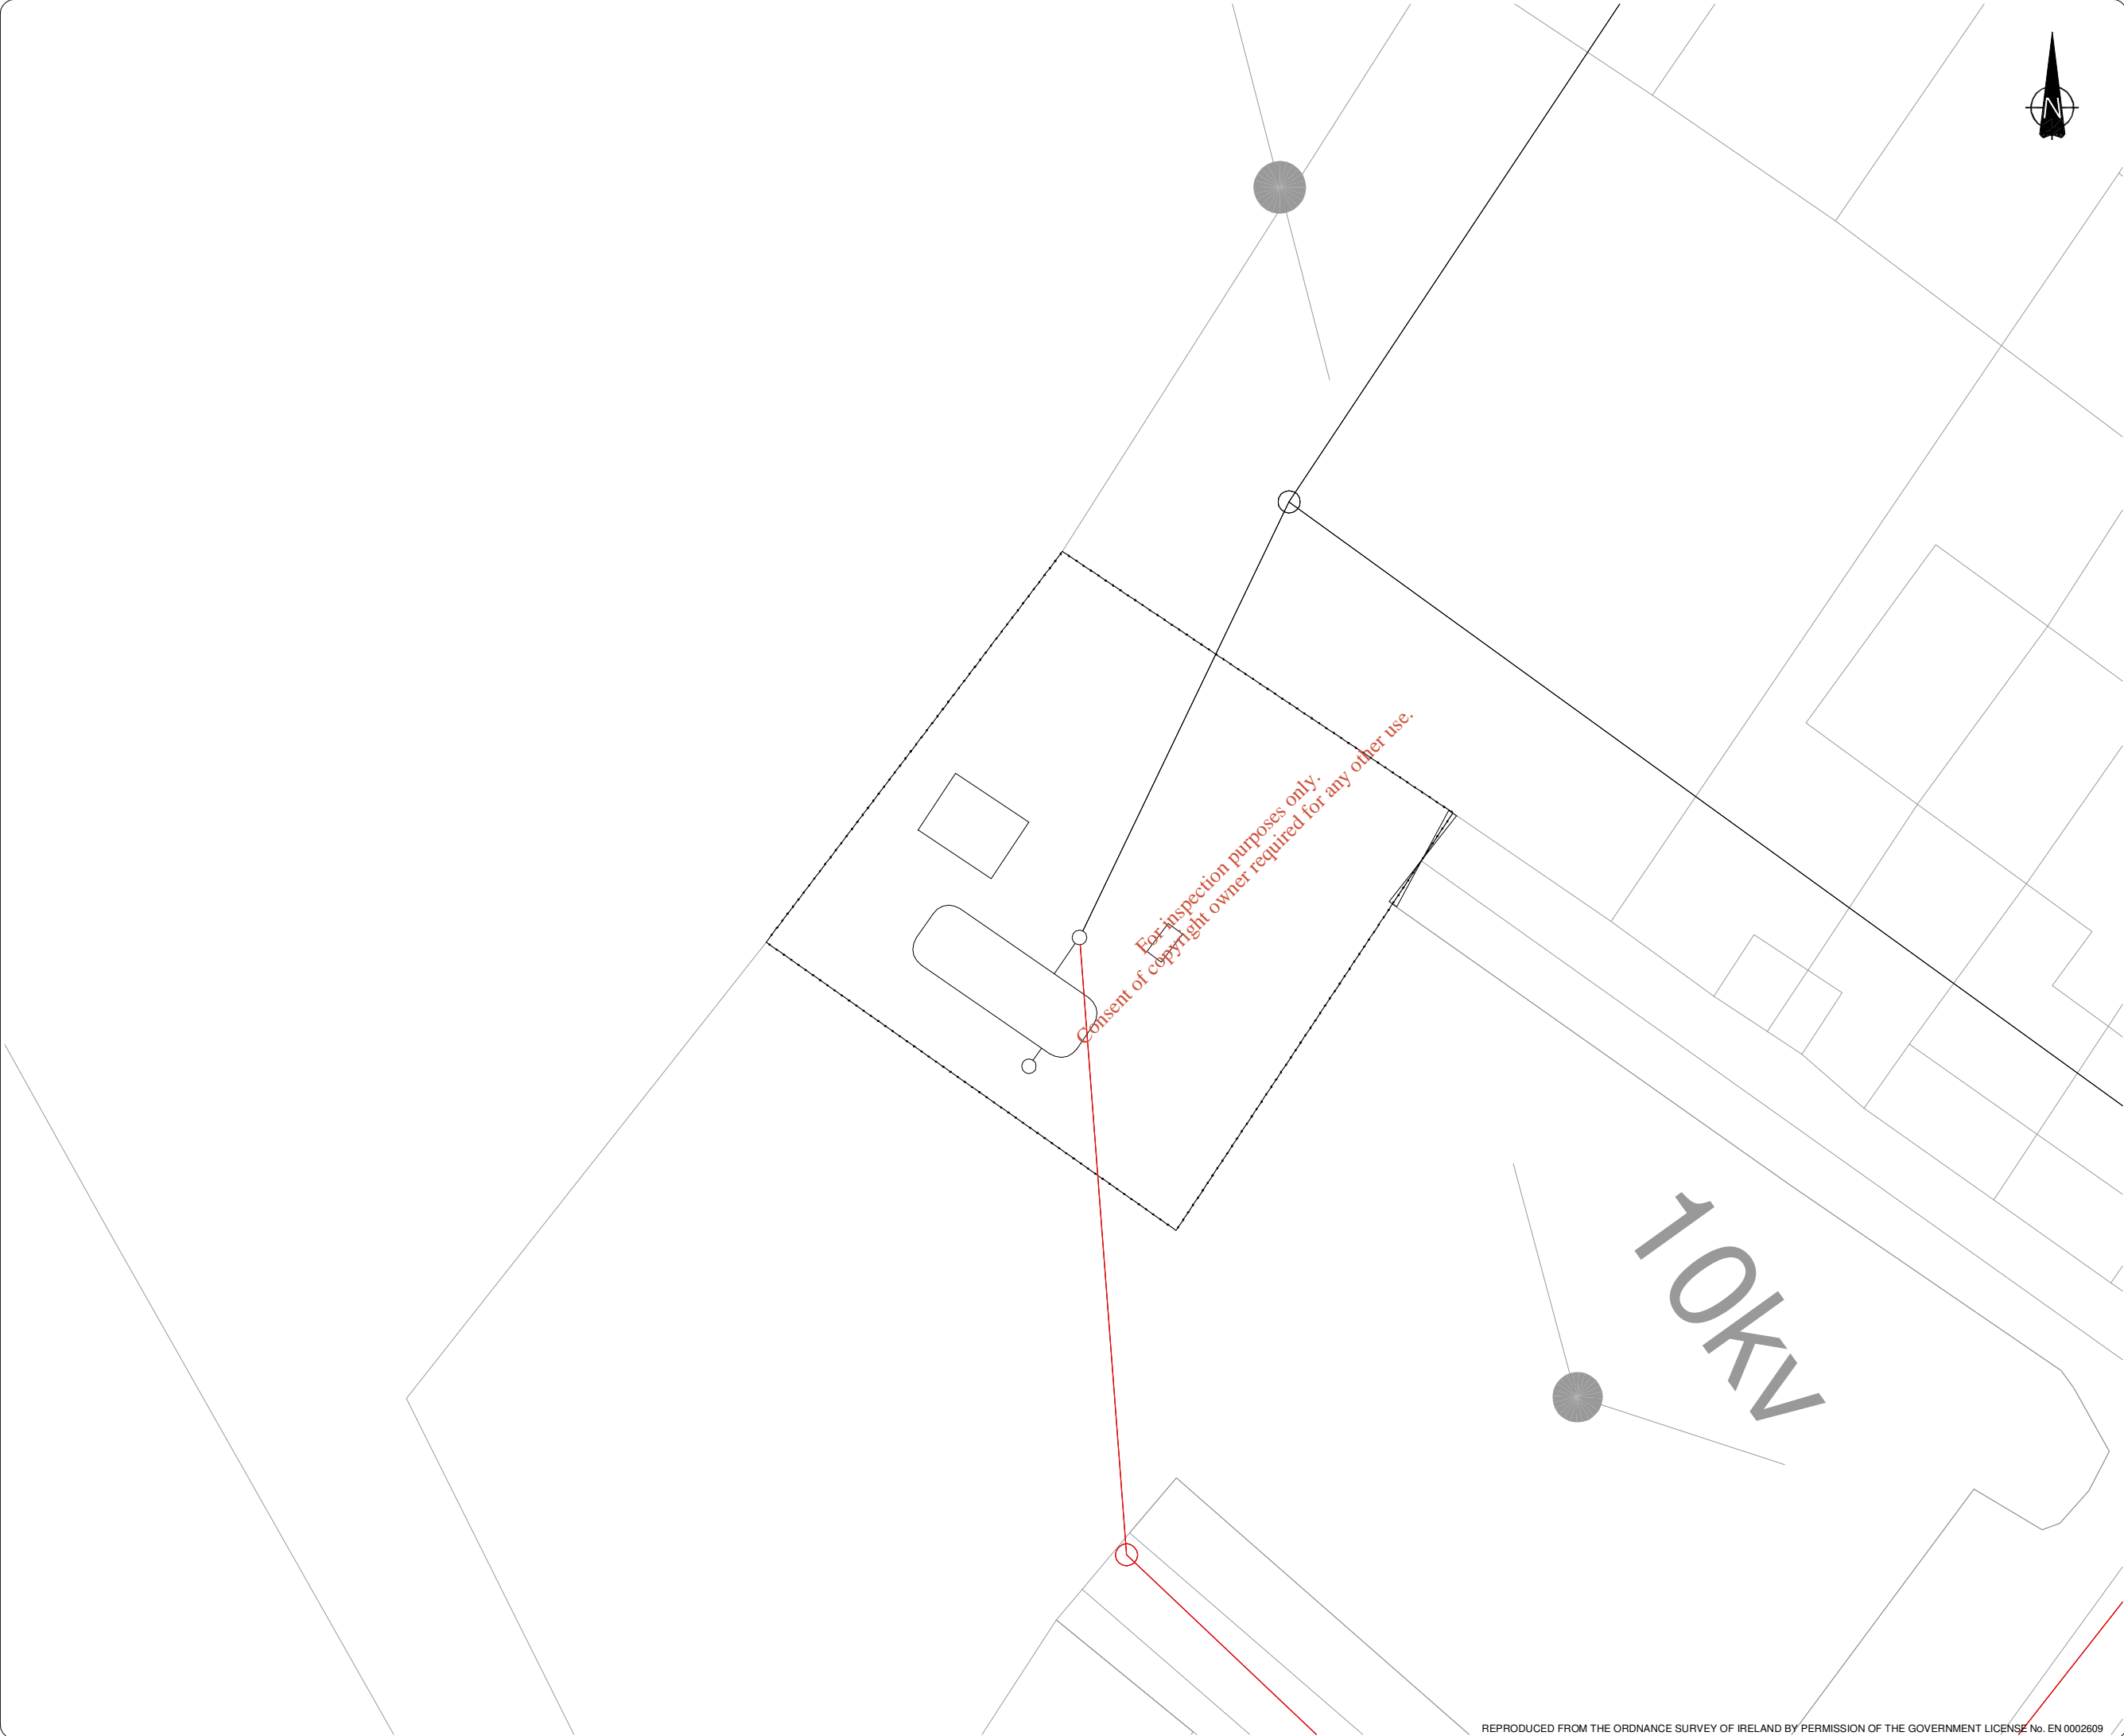

- Notes
- 1. FIGURED DIMENSIONS ONLY TO BE TAKEN FROM THIS DRAWING
 - 2. ALL DRAWINGS TO BE CHECKED BY THE CONTRACTOR ON SITE
 - 3. ENGINEER TO BE INFORMED OF ANY DISCREPANCIES BEFORE ANY WORK COMMENCES.

rev.	modifications	by	da

client

MEATH COUNTY COUNCIL

project

CARNAROSS
SEWERAGE SCHEME

stage

WASTE WATER DISCHARGE
LICENCE APPLICATION

title

ATTACHMENT B.2
EXISTING WASTE WATER
TREATMENT FACILITIES
OVERALL SITE PLAN

scales

1 / 250

drawn

checked

approved

date

TC

YMcG

TMcG

Nov. 2009

© COPYRIGHT OF

JENNINGS O'DONOVAN & PARTNERS
CONSULTING ENGINEERS,
FINISKLIN BUSINESS PARK,
SLIGO.

Tel. (071) 9161416.

Fax. (071) 9161080.

Email info@jodireland.com

drawing no.	revision
4654/OL/06/03	<div></div>

CARNAROS



SW1(P) - EXISTING / PROPOSED
PRIMARY DISCHARGE POINT
268302 EAST
278682 NORTH

EXISTING WASTE WATER
TREATMENT WORKS

For inspection purposes only.
Consent of copyright owner required for any other use.

Borehole Location
268,490 EAST
278,660 NORTH

Notes

1. FIGURED DIMENSIONS ONLY TO BE TAKEN FROM THIS DRAWING
2. ALL DRAWINGS TO BE CHECKED BY THE CONTRACTOR ON SITE
3. ENGINEER TO BE INFORMED OF ANY DISCREPANCIES BEFORE ANY WORK COMMENCES.

LEGEND :


- Existing Foul Sewers
- Existing Older Foul Sewers
- Existing Works
- Existing Primary Discharge Point
- Borehole Location

rev.	modifications			by	da

client			
MEATH COUNTY COUNCIL			
project			
CARNAROSS SEWERAGE SCHEME			
stage			
WASTE WATER DISCHARGE LICENCE APPLICATION			
title			
ATTACHMENT B.3 EXISTING PRIMARY DISCHARGE POINT OVERALL SITE PLAN			
scales			
1 / 1,250			
drawn	checked	approved	date
TC	YMcG	TMcG	Nov. 2009

© COPYRIGHT OF
JENNINGS O'DONOVAN & PARTNERS
CONSULTING ENGINEERS,
FINISKLIN BUSINESS PARK,
SLIGO.
Tel. (071) 9161416.
Fax. (071) 9161080.
Email info@jodireland.com

drawing no.	revision
4654/OL/06/04	

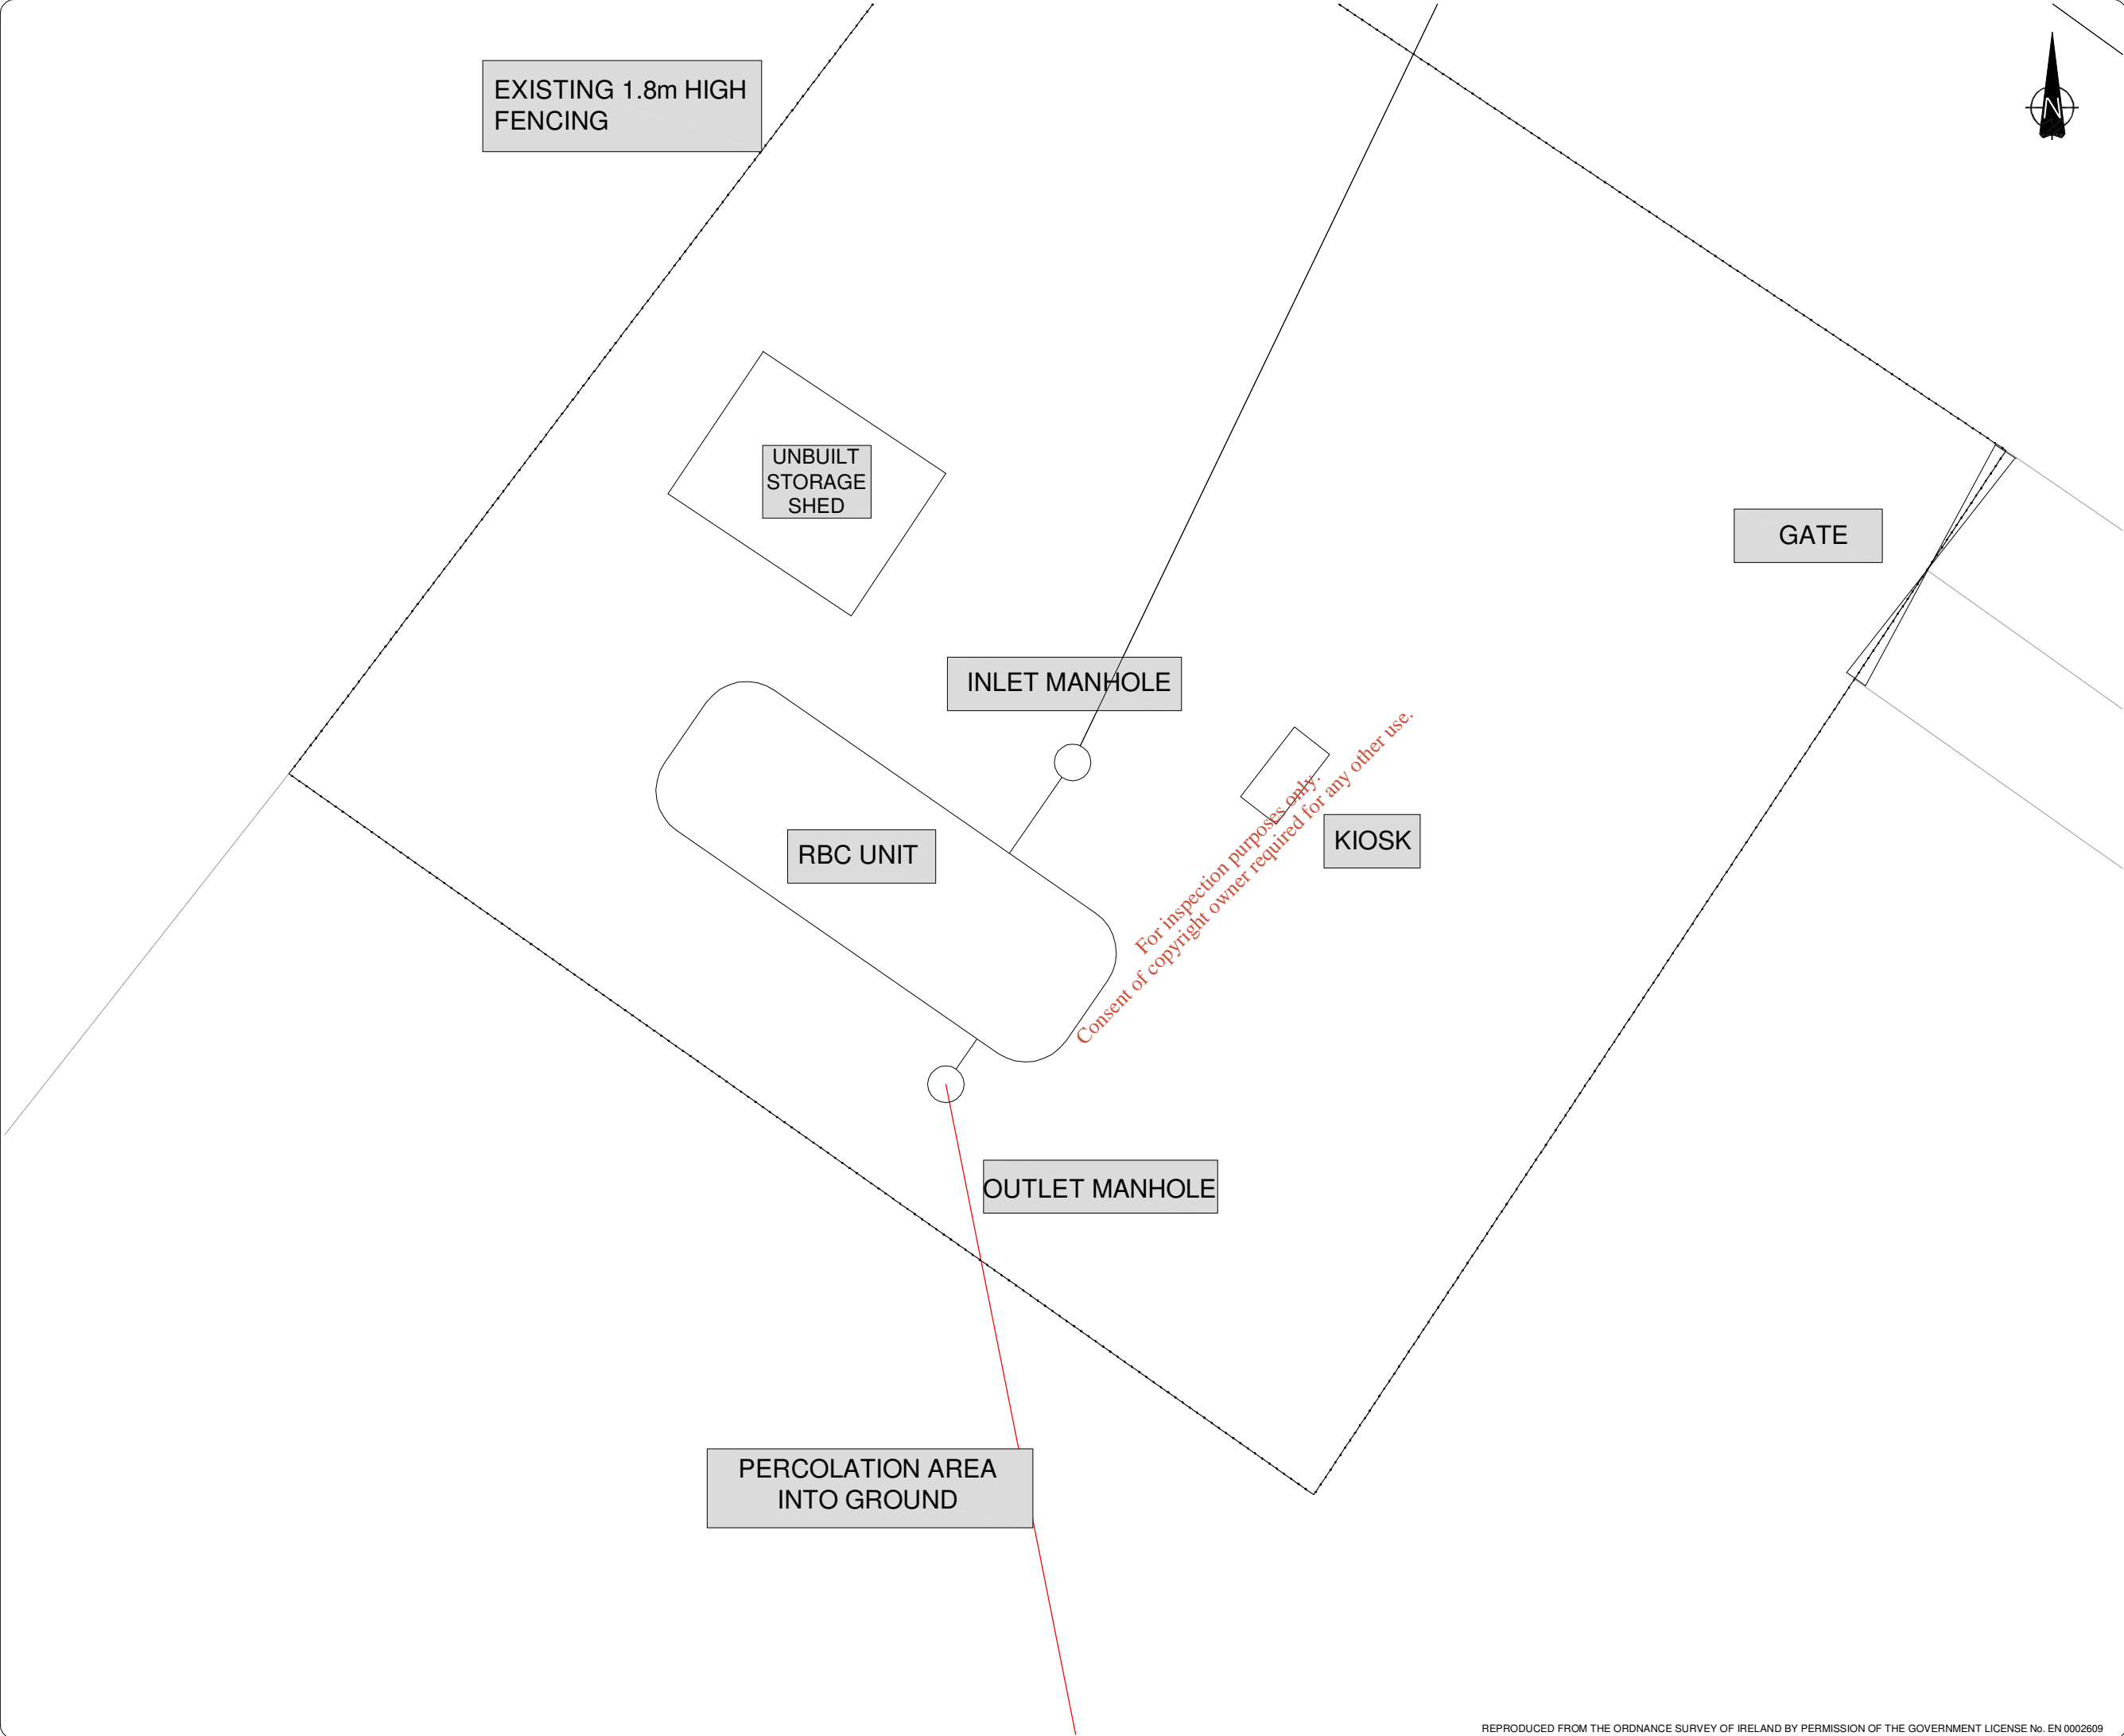

- Notes
- 1. FIGURED DIMENSIONS ONLY TO BE TAKEN FROM THIS DRAWING
 - 2. ALL DRAWINGS TO BE CHECKED BY THE CONTRACTOR ON SITE
 - 3. ENGINEER TO BE INFORMED OF ANY DISCREPANCIES BEFORE ANY WORK COMMENCES.

rev.	modifications	by	da


client			
MEATH COUNTY COUNCIL			
project			
CARNAROSS SEWERAGE SCHEME			
stage			
WASTE WATER DISCHARGE LICENCE APPLICATION			
title			
ATTACHMENT C.1 EXISTING WASTE WATER TREATMENT FACILITIES LAYOUT PLAN			
scales			
1 / 100			
drawn	checked	approved	date
TC	YMcG	TMcG	Nov. 2009

© COPYRIGHT OF

JENNINGS O'DONOVAN & PARTNERS
CONSULTING ENGINEERS,
FINISKLIN BUSINESS PARK,
SLIGO.

Tel. (071) 9161416.
Fax. (071) 9161080.
Email info@jodireland.com

drawing no.	revision									
4654/OL/06/05										

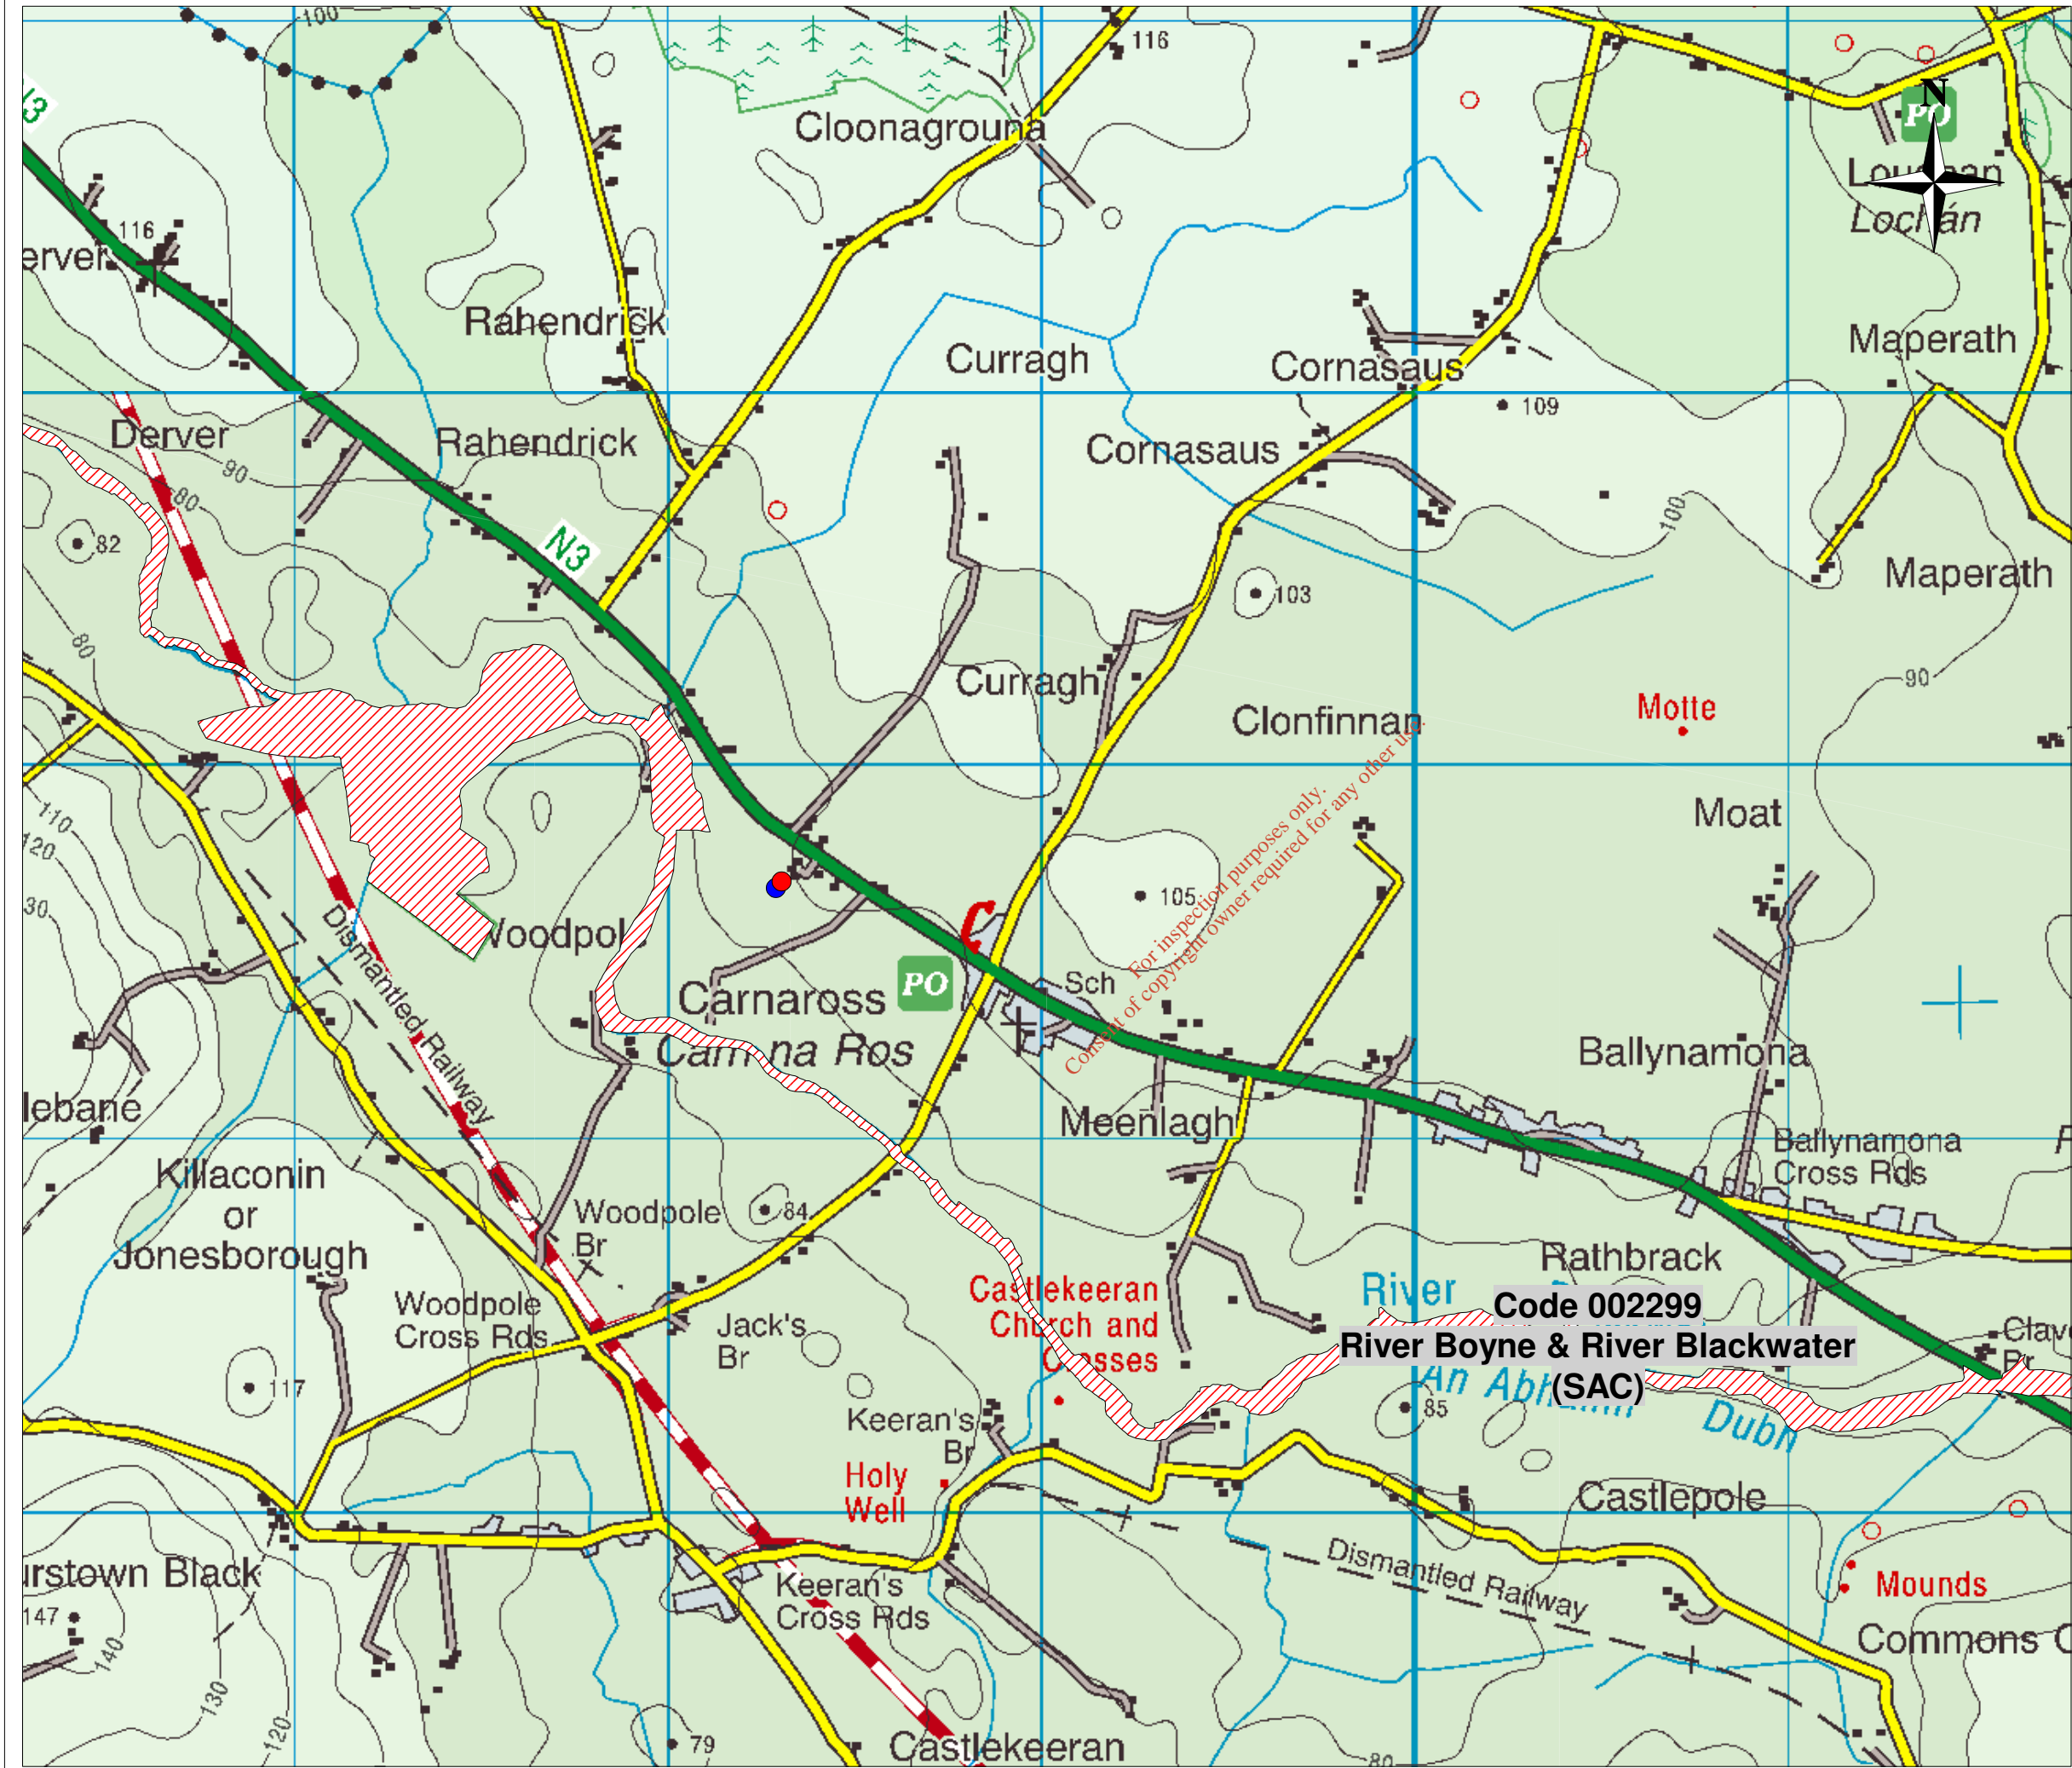

NOTES

Figured dimensions only to be taken from this drawing
All dimensions to be checked on site.

All Levels are in Metres and Relate to O.S. Datum Malin
All Maps are Referenced to Irish National Grid (I.N.G.)

Ordnance Survey of Ireland Licence No.EN 0002609
© Government of Ireland

Key Map Features

- Waste Water Treatment Plant
- Primary Discharge Point

SAC

SPA

pNHA / NHA

Rev:	Description:	Drawn:	Ch'kd:	Date:
Client:				
MEATH COUNTY COUNCIL				
Client Representative:				
<p>JENNINGS O'DONOVAN CONSULTING ENGINEERS</p>				
Project:				
Waste Water Discharge Certificate Authorisation				
Drawing Title:				
Carnaross Attachment F.1 Designation Map				
Drawn By:	T.C	Date:	December 09	
Checked By:	Y.McM	Date:	December 09	
Stage:	Waste Water Discharge Certificate			
Scales:	N.T.S.			
Drawing No.	4654/OL/06/06			Revision: