



Comhairle Chontae Na Mí
Meath County Council

BOHERMEEN SEWERAGE SCHEME
OUTFALL LICENCE APPLICATION

For inspection purposes only
Consent of copyright owner required for any other use

4654/OL/05/00	Schedule of Drawings
4654/OL/05/01	Attachment A.1 - Site Location Map
4654/OL/05/02	Attachment B.1 - Agglomeration Outline Plan
4654/OL/05/03	Attachment B.2 - Existing Waste Water Treatment Facilities - Overall Site Plan
4654/OL/05/04	Attachment B.3 - Existing Primary Discharge Point
4654/OL/05/05	Attachment C.1 - Existing Waste Water Treatment Facilities - Layout Plan
4654/OL/05/06	Attachment F.1 - Designation Map

Notes

1. FIGURED DIMENSIONS ONLY TO BE TAKEN FROM THIS DRAWING

2. ALL DRAWINGS TO BE CHECKED BY THE CONTRACTOR ON SITE.

3. ENGINEER TO BE INFORMED OF ANY DISCREPANCIES BEFORE ANY WORK COMMENCES.

rev.	modifications		by	ds	

client

MEATH COUNTY COUNCIL

project

BOHERMEEN
SEWERAGE SCHEME

stage

WASTE WATER DISCHARGE
LICENCE APPLICATION

title

SCHEDULE OF DRAWINGS

scales

N/A

drawn

checked

approved

date

TC

YMcG

TMcG

Nov. 2009

© COPYRIGHT OF



JENNINGS O'DONOVAN & PARTNERS
CONSULTING ENGINEERS,
FINISKLIN BUSINESS PARK,
SLIGO.

Tel. (071) 9161416.
Fax. (071) 9161080.
Email info@jodireland.com

drawing no.

4654/OL/05/00

revision

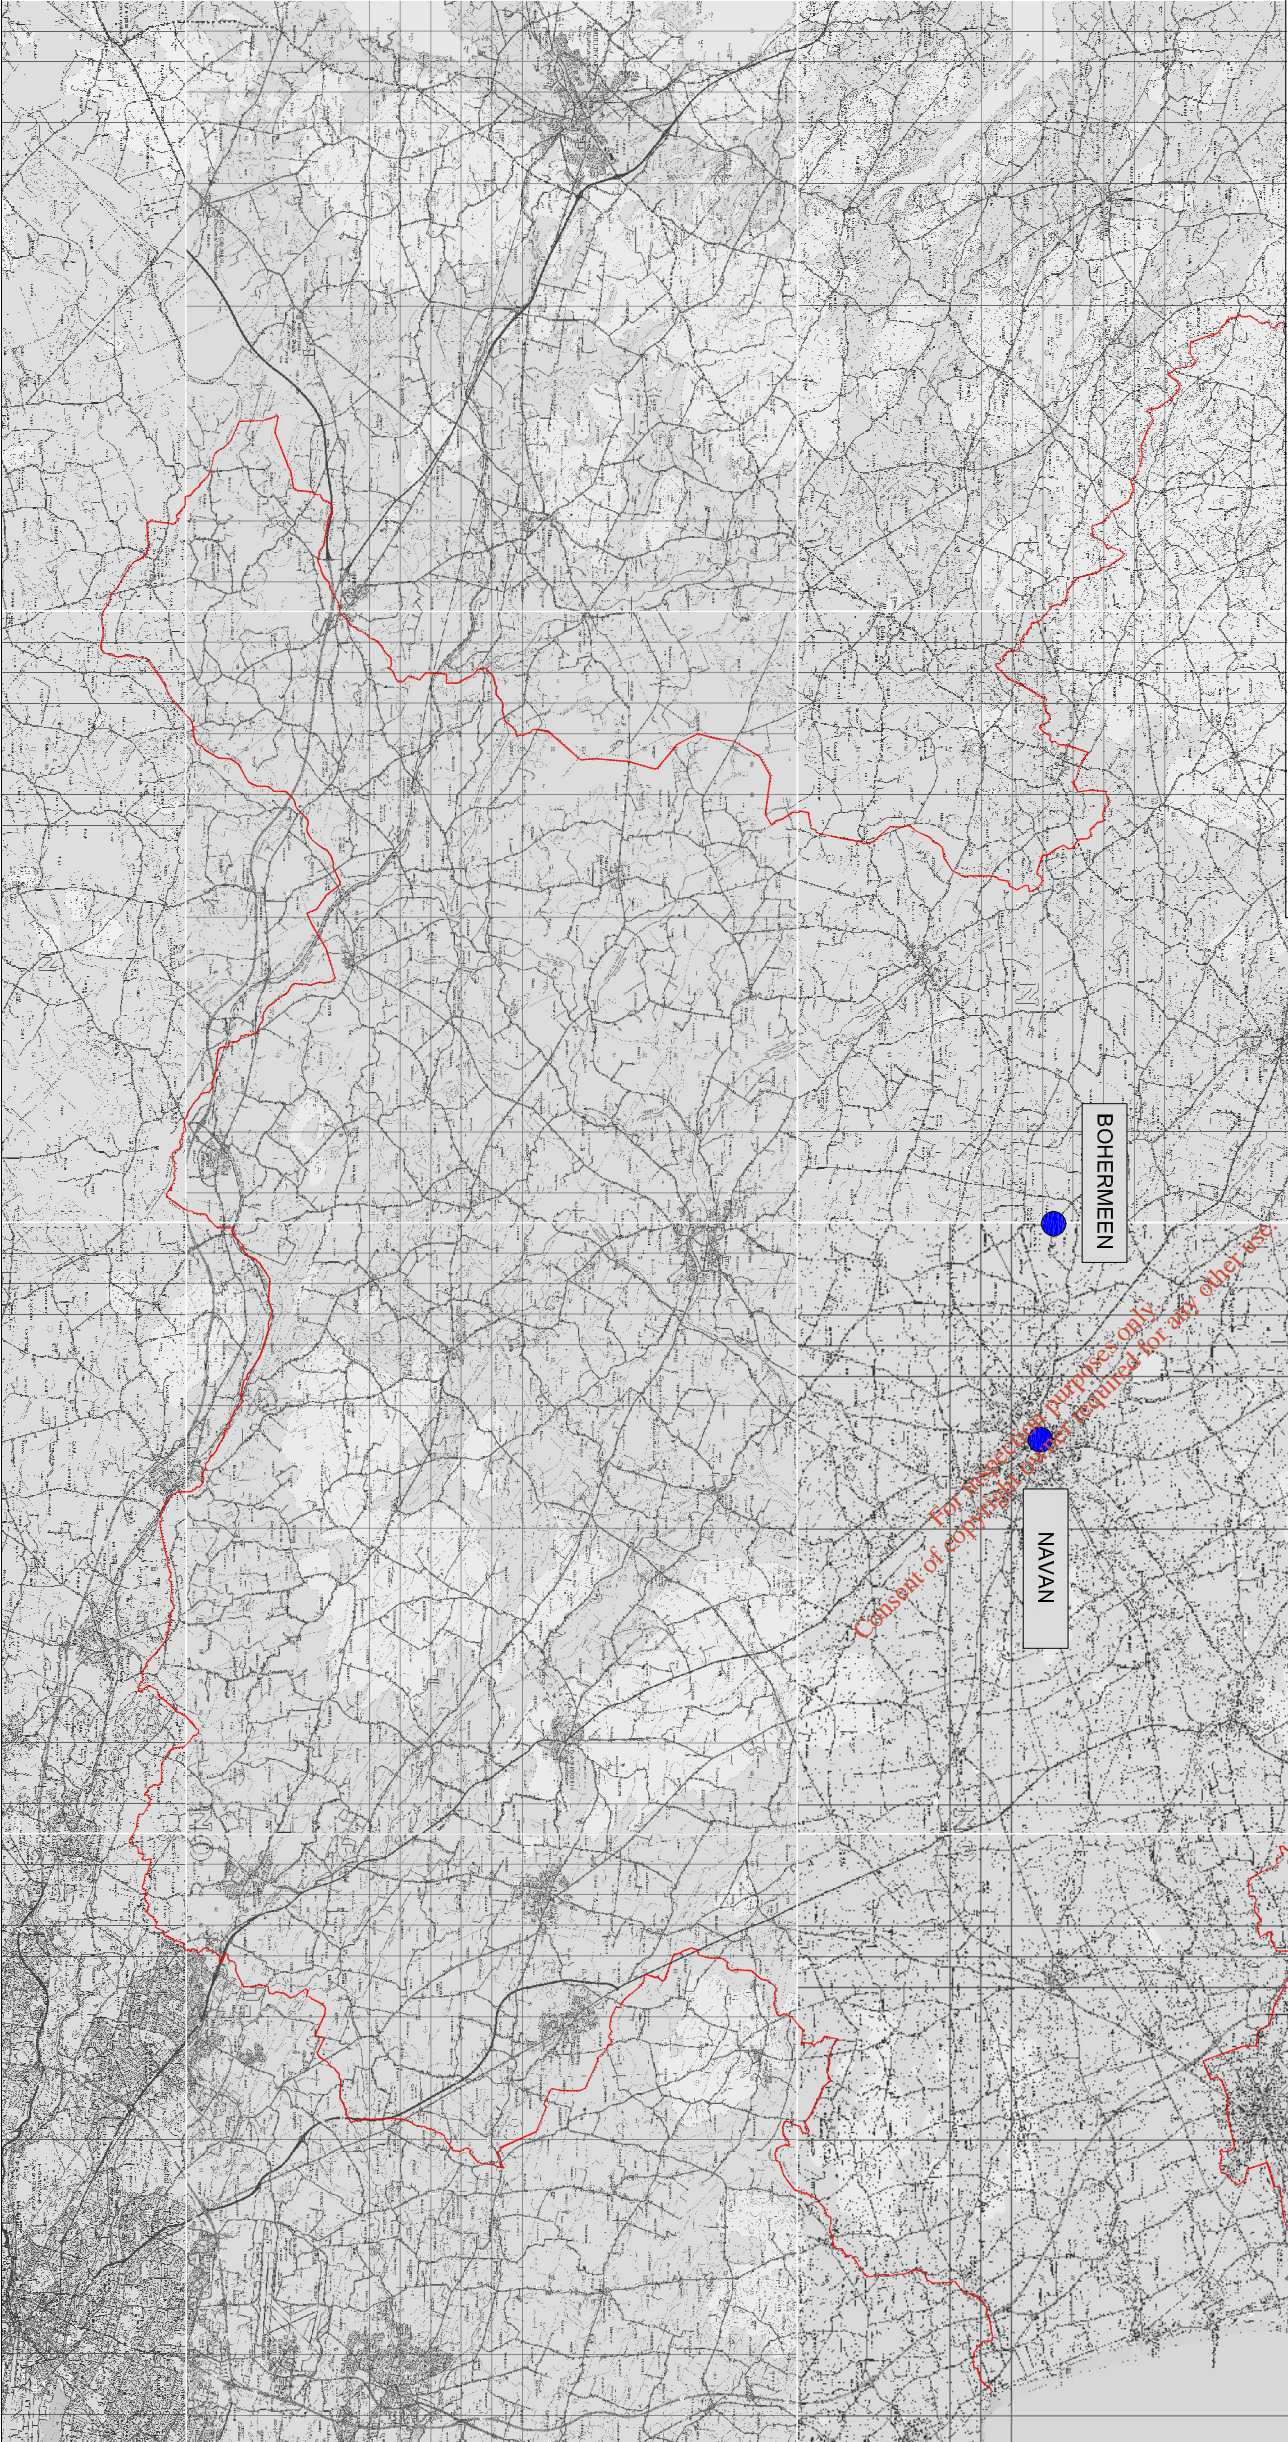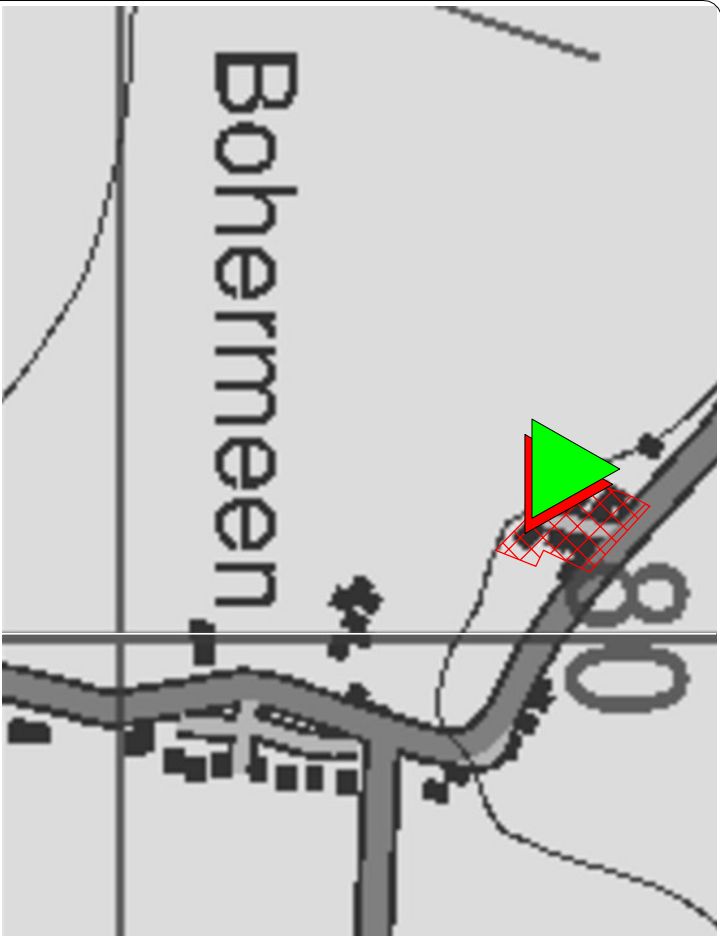

Notes

1. FIGURED DIMENSIONS ONLY TO BE TAKEN FROM THIS DRAWING.
2. ALL DRAWINGS TO BE CHECKED BY THE CONTRACTOR ON SITE.
3. ENGINEER TO BE INFORMED OF ANY DISCREPANCIES BEFORE ANY WORK COMMENCES.

LEGEND:



AGGLOMERATION CATCHMENT AREA



EXISTING TREATMENT WORKS



EXISTING TREATED EFFLUENT
DISCHARGE POINT

[illegible]

client

MEATH COUNTY COUNCIL

project
**BOHERMEEN
SEWERAGE SCHEME**

stage
WASTE WATER DISCHARGE
LICENCE APPLICATION

title
ATTACHMENT A.1
LOCATION MAP

scales

 $1 / 10,000 \text{ \& } 1 / 250,000$

TC	YMcG	TMcG	Nov. 2009
----	------	------	-----------

© COPYRIGHT OF

**JENNINGS O'DONOVAN & PARTNERS
CONSULTING ENGINEERS,
FINISKILIN BUSINESS PARK,
SLIGO.**



Tel. (071) 9161416.
Fax. (071) 9161080.
Email info@jodireland.com

drawing no.

 


4654/OL/05/01

revision



- Notes
1. FIGURED DIMENSIONS ONLY TO BE TAKEN FROM THIS DRAWING
 2. ALL DRAWINGS TO BE CHECKED BY THE CONTRACTOR ON SITE
 3. ENGINEER TO BE INFORMED OF ANY DISCREPANCIES BEFORE ANY WORK COMMENCES.

LEGEND :

-  Agglomeration Catchment Area
-  Existing Sewers
-  Existing Works

EXISTING WASTE WATER
TREATMENT WORKS

For inspection purposes only.
Content of copyright owner required for any other use.

rev.	modifications	by	da


client			
MEATH COUNTY COUNCIL			
project			
BOHERMEEN SEWERAGE SCHEME			
stage			
WASTE WATER DISCHARGE LICENCE APPLICATION			
title			
ATTACHMENT B.1 AGGLOMERATION OUTLINE PLAN			
scales			
1 / 1,000			
drawn	checked	approved	date
TC	YMcG	TMcG	Nov. 2009

© COPYRIGHT OF
JENNINGS O'DONOVAN & PARTNERS
CONSULTING ENGINEERS,
FINISKLIN BUSINESS PARK,
SLIGO.

Tel. (071) 9161416.
Fax. (071) 9161080.
Email info@jodireland.com



drawing no.	revision										
4654/OL/05/02	<table><tr><td></td><td></td><td></td><td></td><td></td><td></td><td></td><td></td><td></td><td></td></tr></table>										

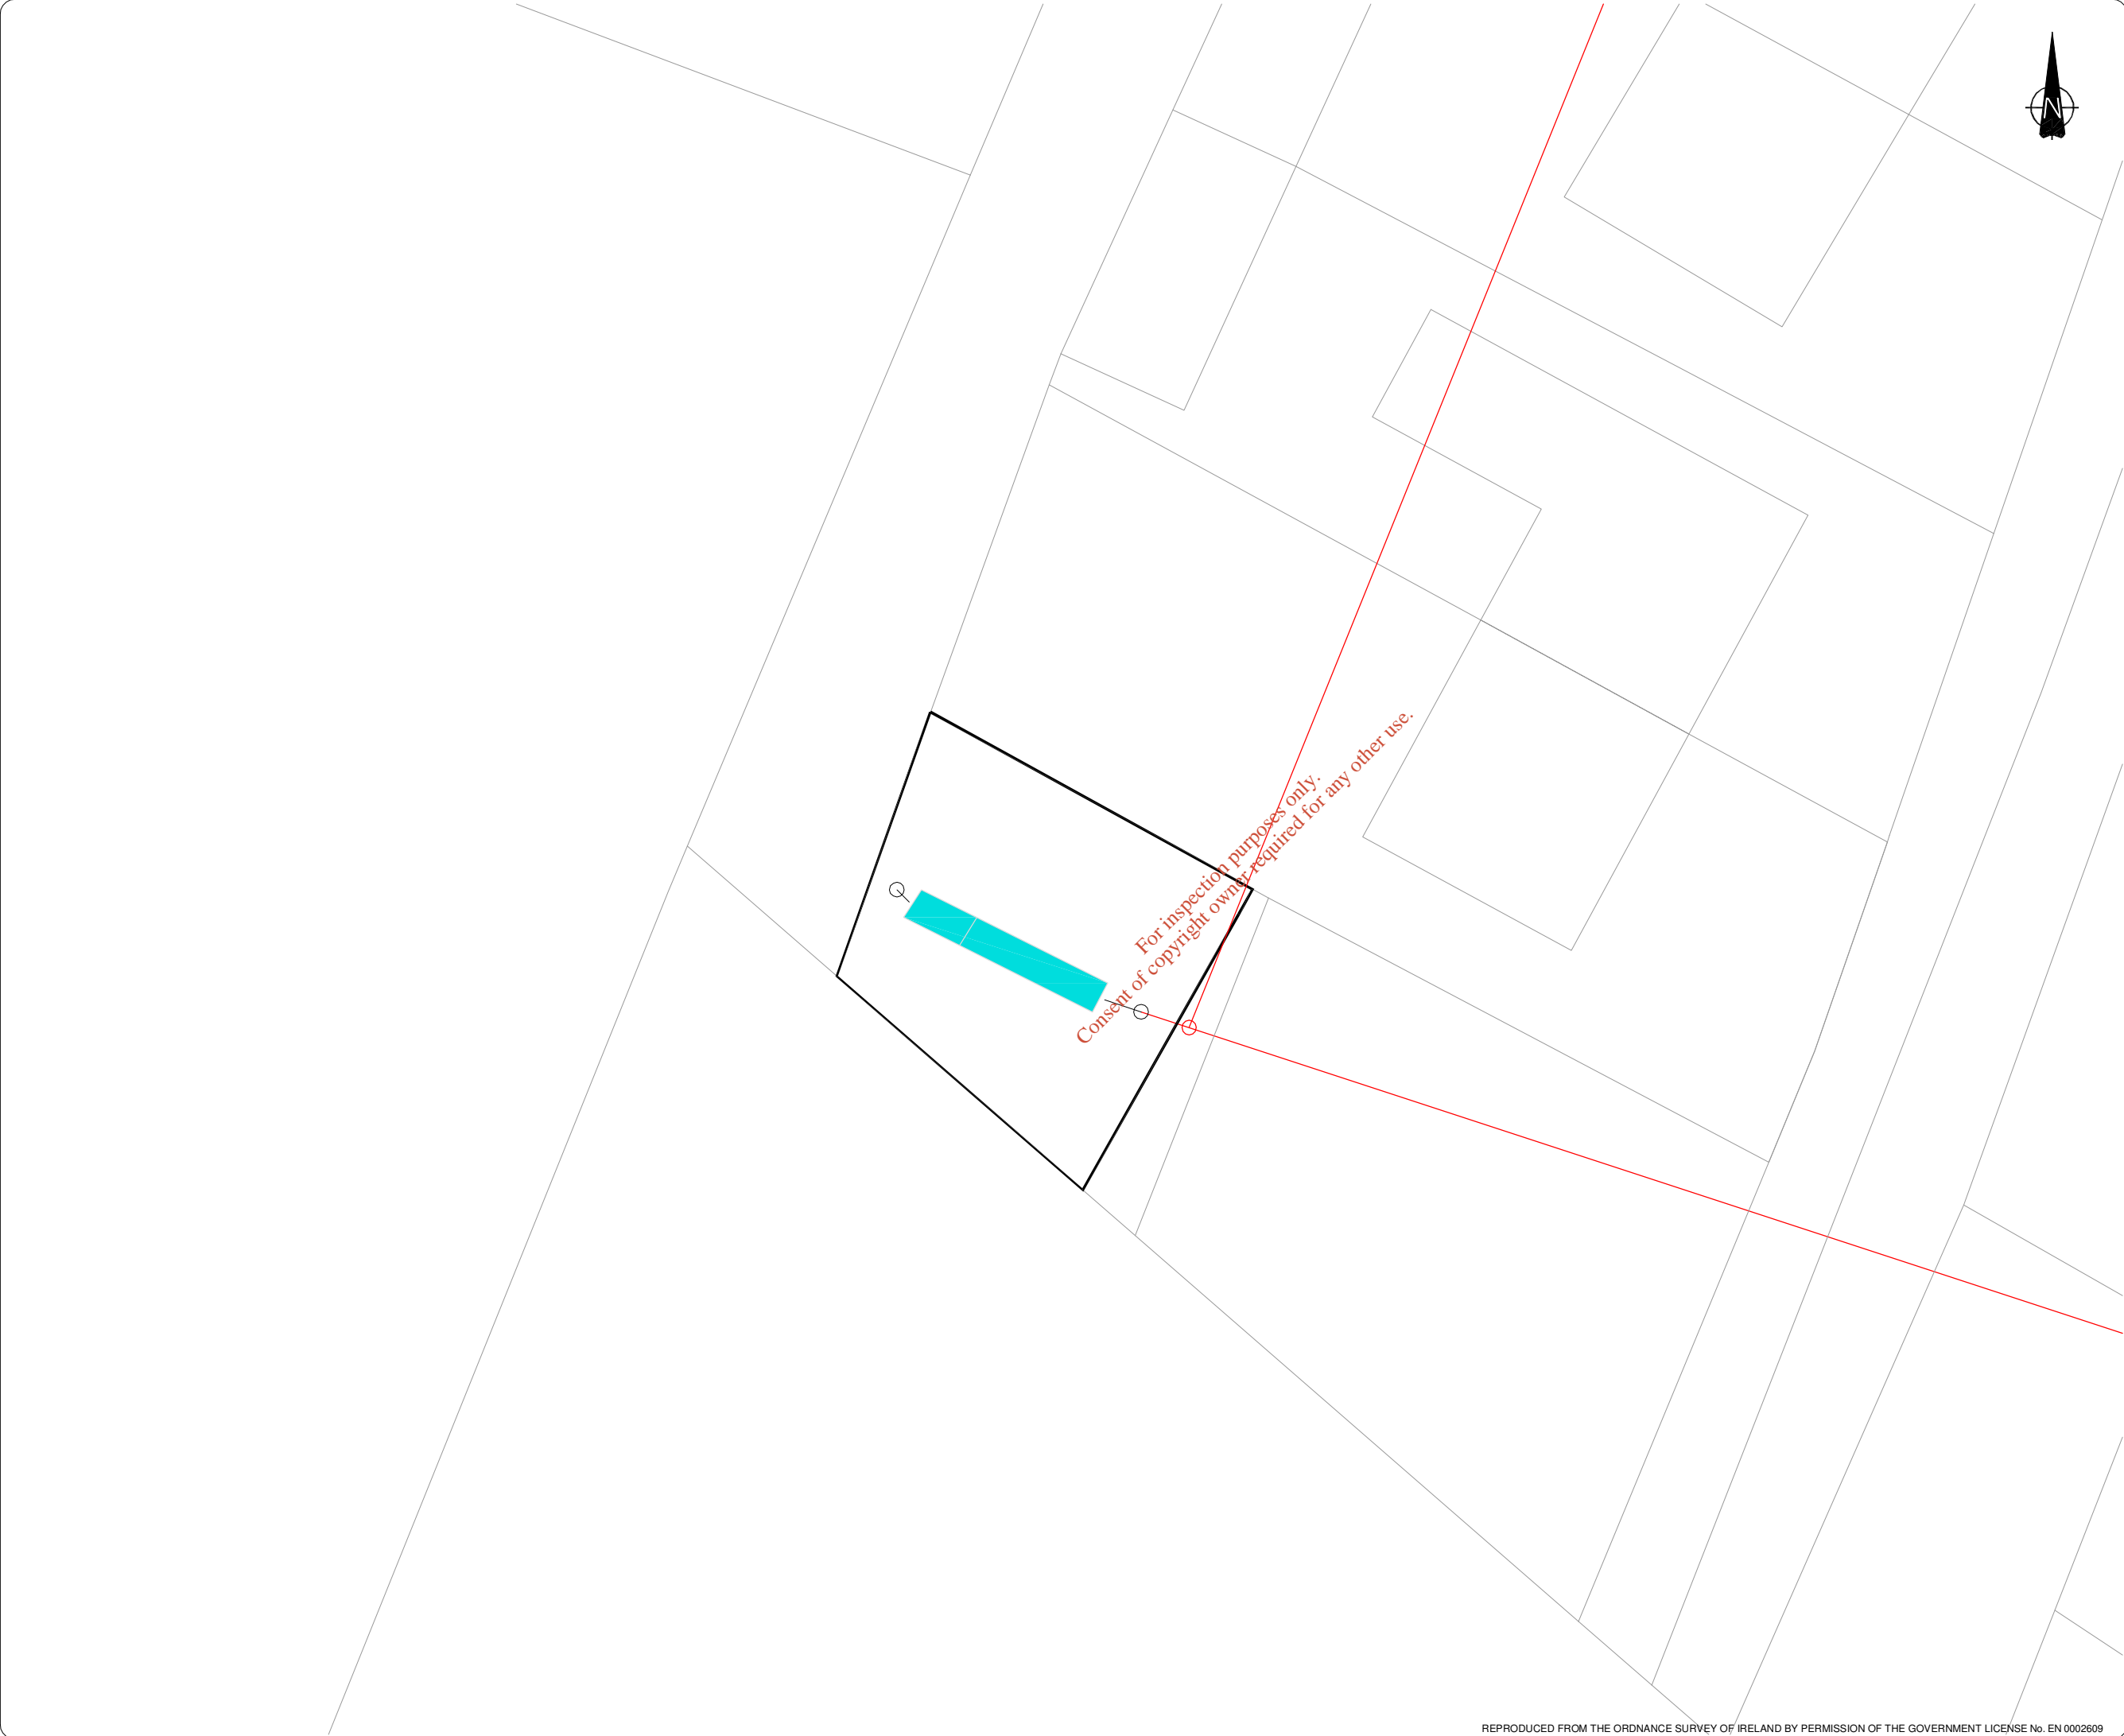

Notes

- 1. FIGURED DIMENSIONS ONLY TO BE TAKEN FROM THIS DRAWING
- 2. ALL DRAWINGS TO BE CHECKED BY THE CONTRACTOR ON SITE
- 3. ENGINEER TO BE INFORMED OF ANY DISCREPANCIES BEFORE ANY WORK COMMENCES.

rev.	modifications	by	da

client

MEATH COUNTY COUNCIL

project

BOHERMEEN
SEWERAGE SCHEME

stage

WASTE WATER DISCHARGE
LICENCE APPLICATION

title

ATTACHMENT B.2
EXISTING WASTE WATER
TREATMENT FACILITIES
OVERALL SITE PLAN

scales

1 / 250

drawn

checked

approved

date

TC

YMcG

TMcG

Nov. 2009

© COPYRIGHT OF


JENNINGS O'DONOVAN & PARTNERS
CONSULTING ENGINEERS,
FINISKLIN BUSINESS PARK,
SLIGO.

Tel. (071) 9161416.

Fax. (071) 9161080.

Email info@jodireland.com

drawing no.	revision
4654/OL/05/03	<div></div>

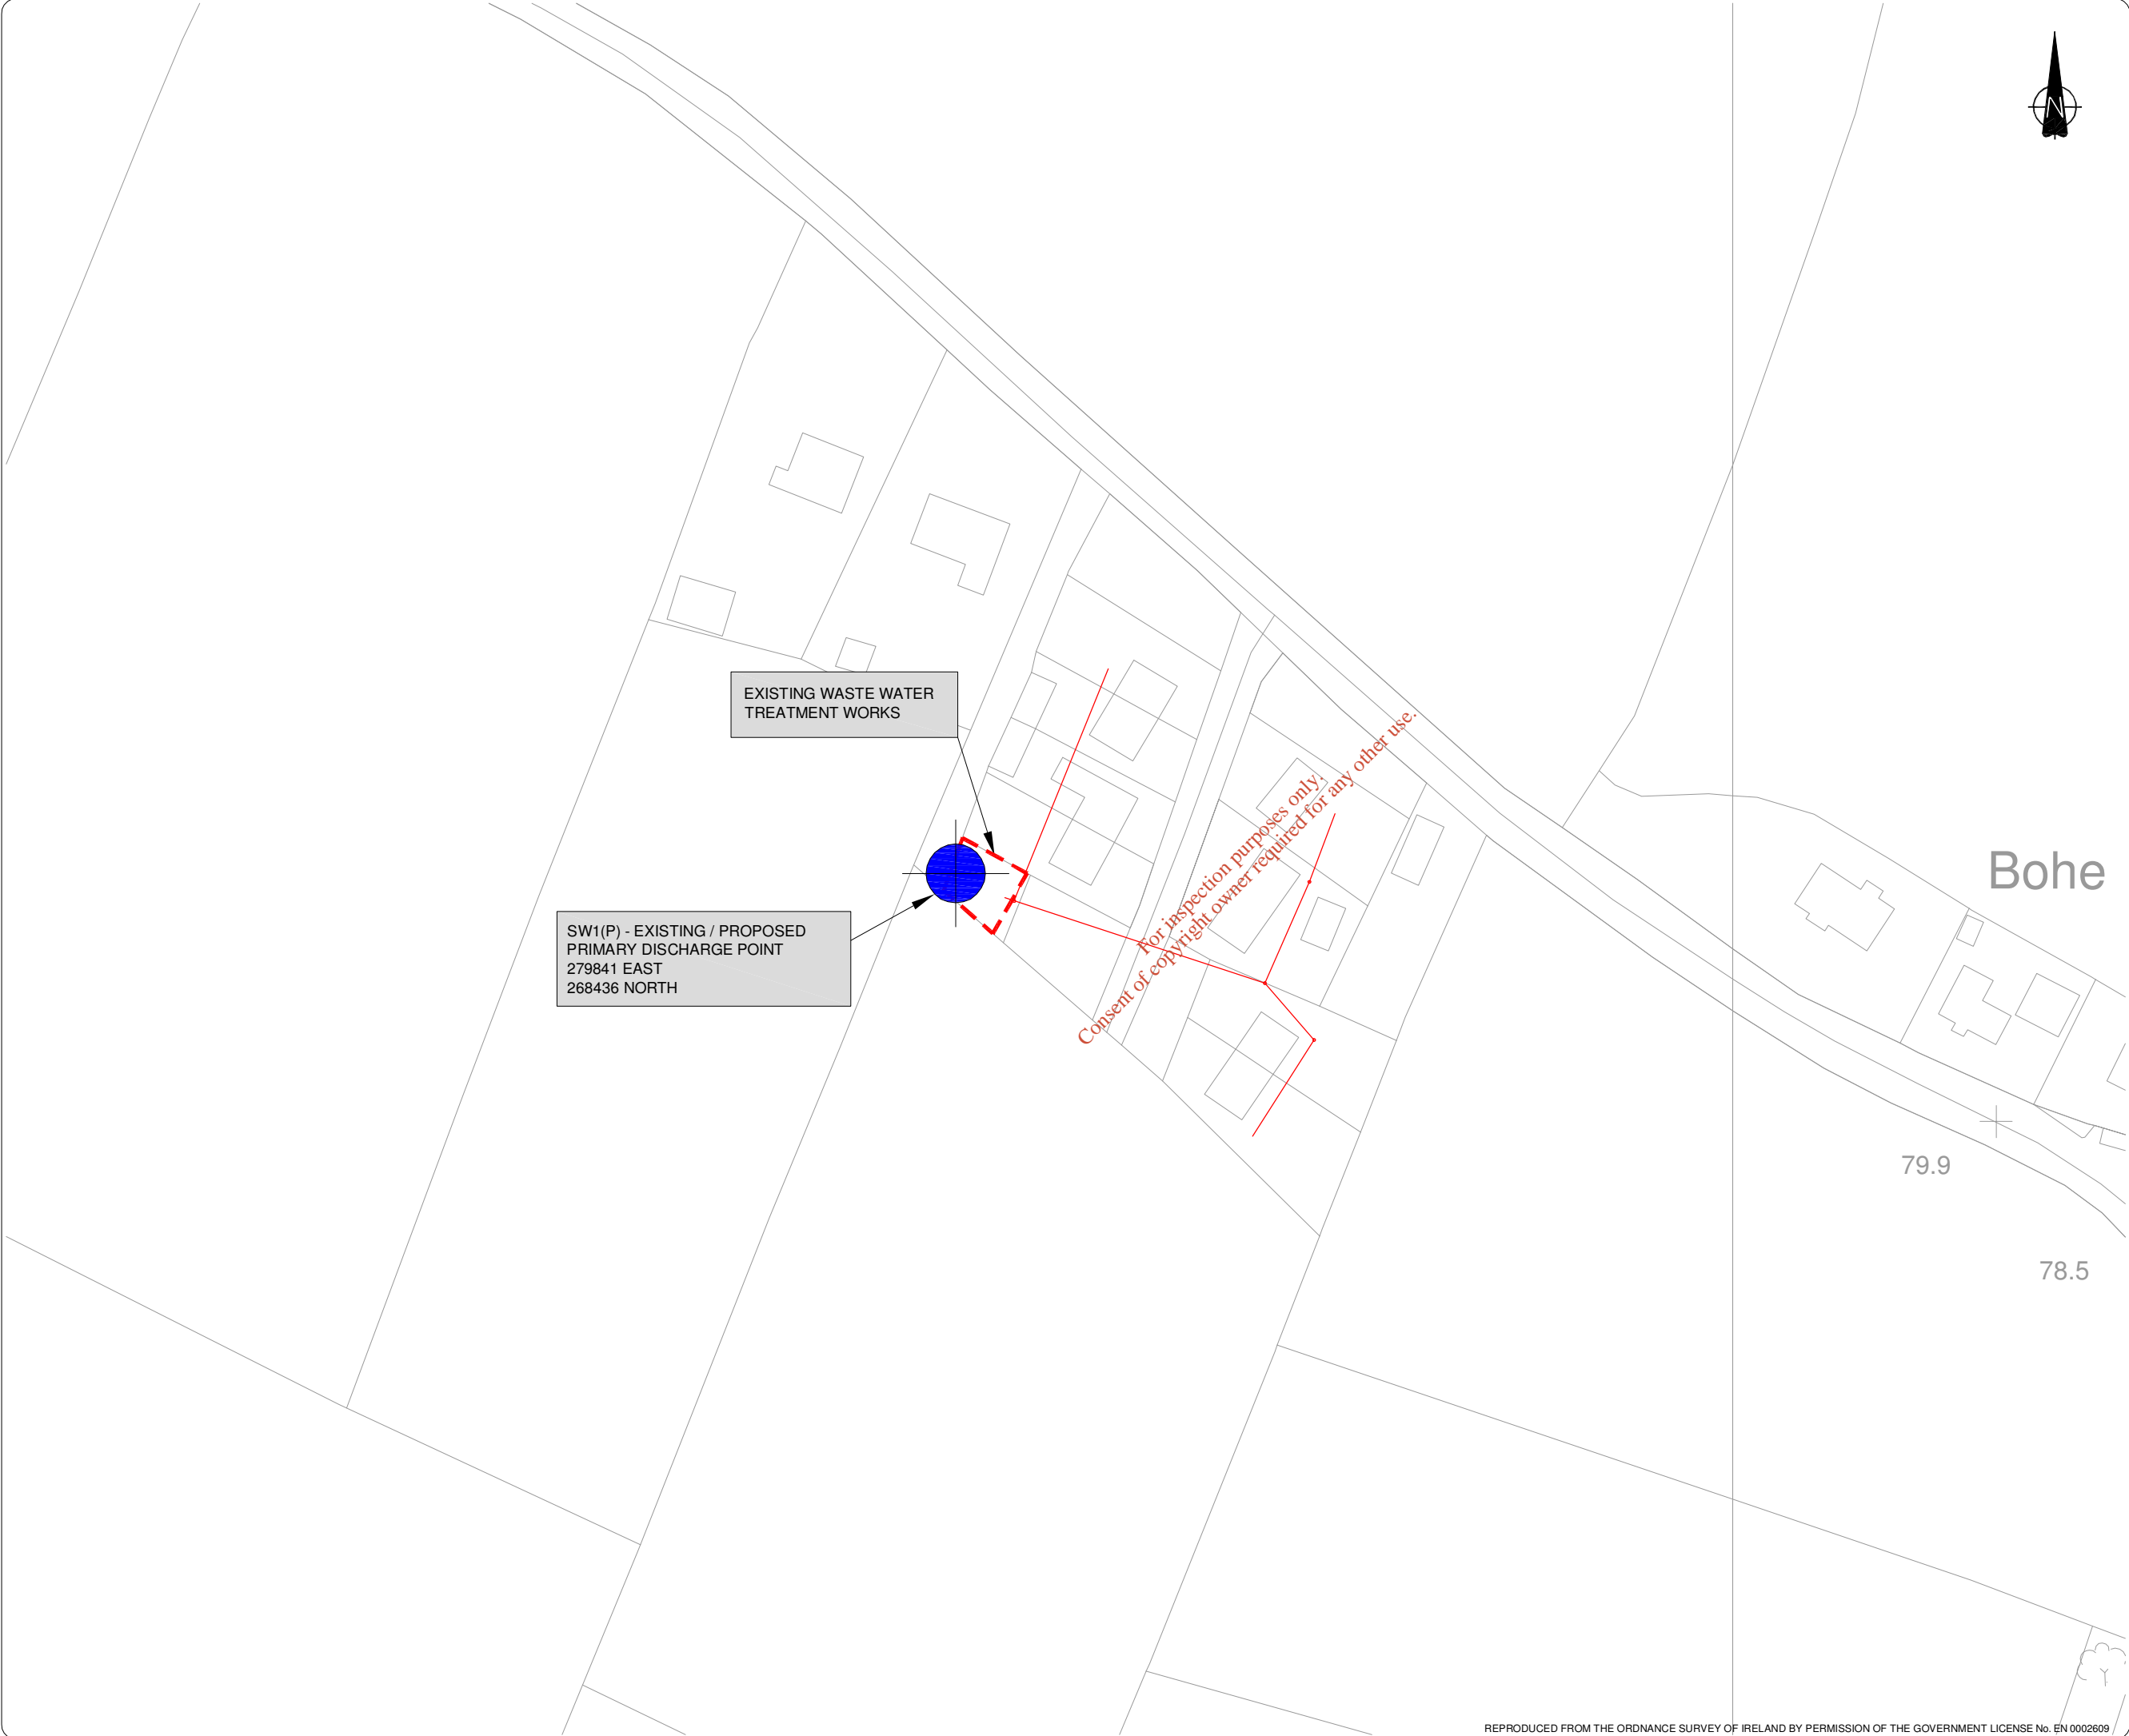

Notes

- 1. FIGURED DIMENSIONS ONLY TO BE TAKEN FROM THIS DRAWING
- 2. ALL DRAWINGS TO BE CHECKED BY THE CONTRACTOR ON SITE
- 3. ENGINEER TO BE INFORMED OF ANY DISCREPANCIES BEFORE ANY WORK COMMENCES.

LEGEND :

- Existing Foul Sewers
- Existing Works
- Existing Primary Discharge Point

rev.	modifications	by	da

client

MEATH COUNTY COUNCIL

project

BOHERMEEN
SEWERAGE SCHEME

stage

WASTE WATER DISCHARGE
LICENCE APPLICATION

title

ATTACHMENT B.3
EXISTING PRIMARY DISCHARGE
POINT
OVERALL SITE PLAN

scales

1 / 1,250

drawn

checked

approved

date

TC

YMcG

TMcG


Nov. 2009

© COPYRIGHT OF

JENNINGS O'DONOVAN & PARTNERS
CONSULTING ENGINEERS,
FINISKLIN BUSINESS PARK,
SLIGO.

Tel. (071) 9161416.
Fax. (071) 9161080.
Email info@jodireland.com

drawing no.	revision							
4654/OL/05/04								

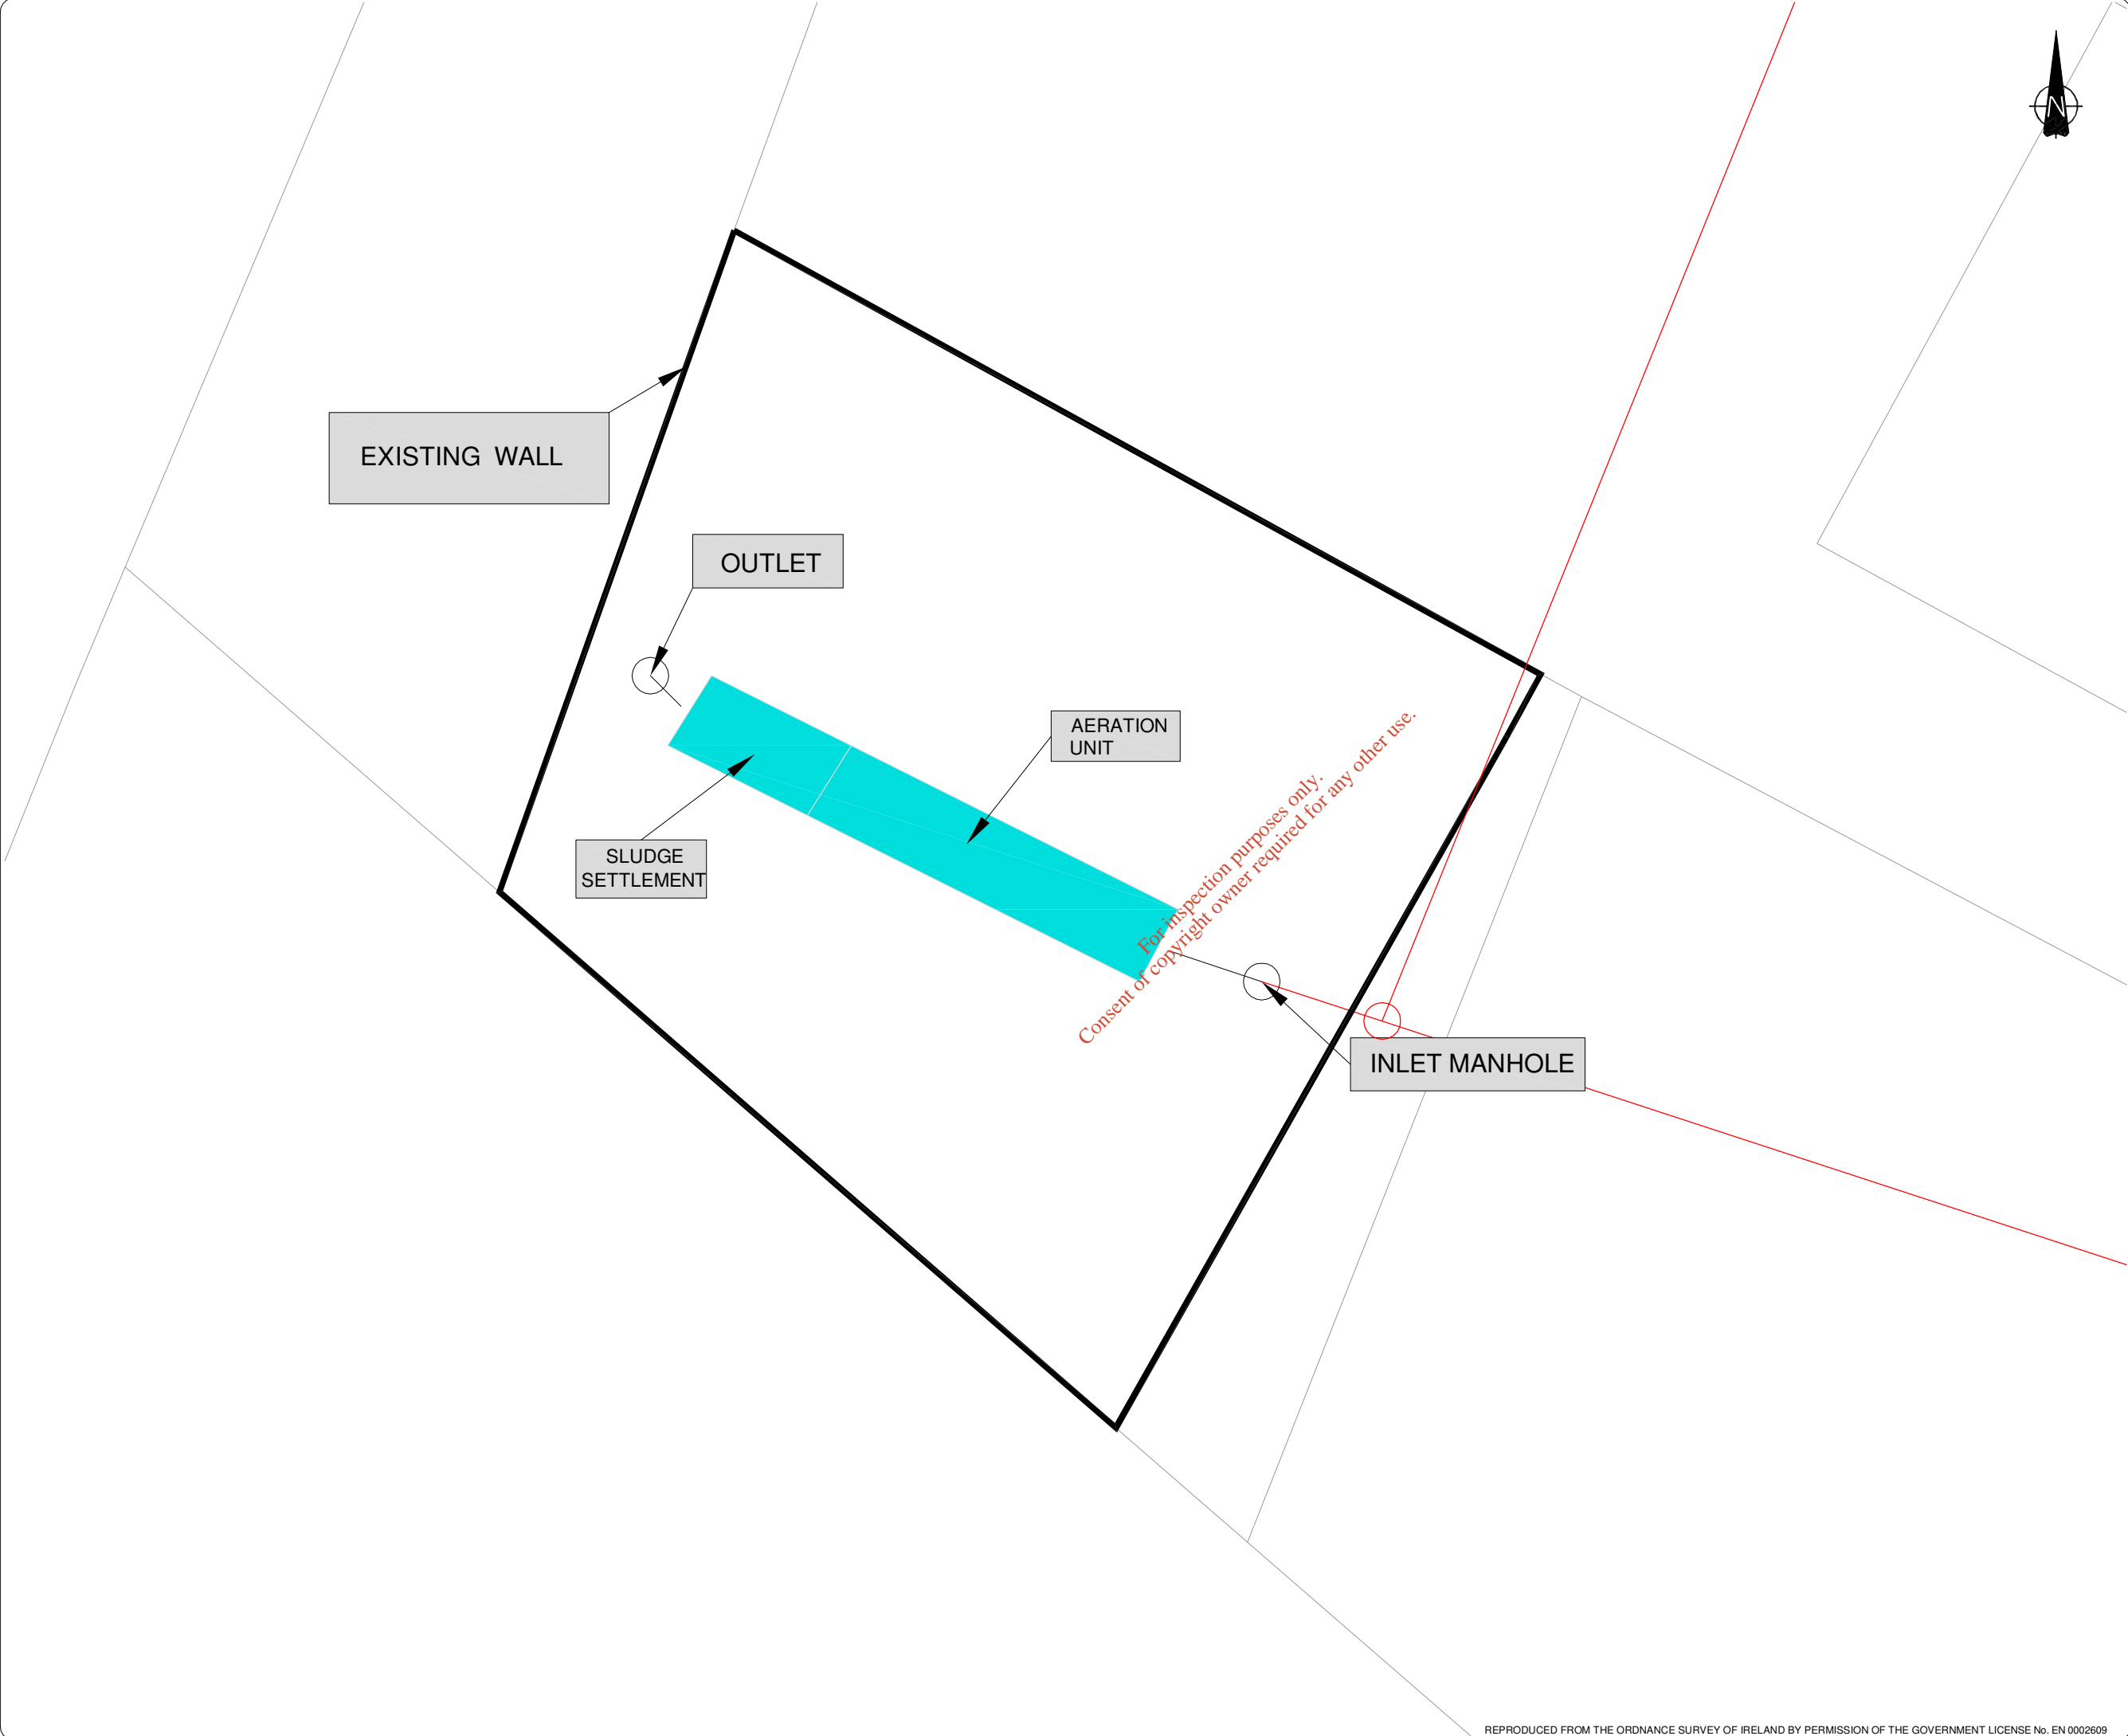

- Notes
- 1. FIGURED DIMENSIONS ONLY TO BE TAKEN FROM THIS DRAWING
 - 2. ALL DRAWINGS TO BE CHECKED BY THE CONTRACTOR ON SITE
 - 3. ENGINEER TO BE INFORMED OF ANY DISCREPANCIES BEFORE ANY WORK COMMENCES.

rev.	modifications	by	da


client			
MEATH COUNTY COUNCIL			
project			
BOHERMEEN SEWERAGE SCHEME			
stage			
WASTE WATER DISCHARGE LICENCE APPLICATION			
title			
ATTACHMENT C.1 EXISTING WASTE WATER TREATMENT FACILITIES LAYOUT PLAN			
scales			
1 / 100			
drawn	checked	approved	date
TC	YMcG	TMcG	Nov. 2009

© COPYRIGHT OF

JENNINGS O'DONOVAN & PARTNERS
CONSULTING ENGINEERS,
FINISKLIN BUSINESS PARK,
SLIGO.

Tel. (071) 9161416.
Fax. (071) 9161080.
Email info@jodireland.com

drawing no.	revision							
4654/OL/05/05								

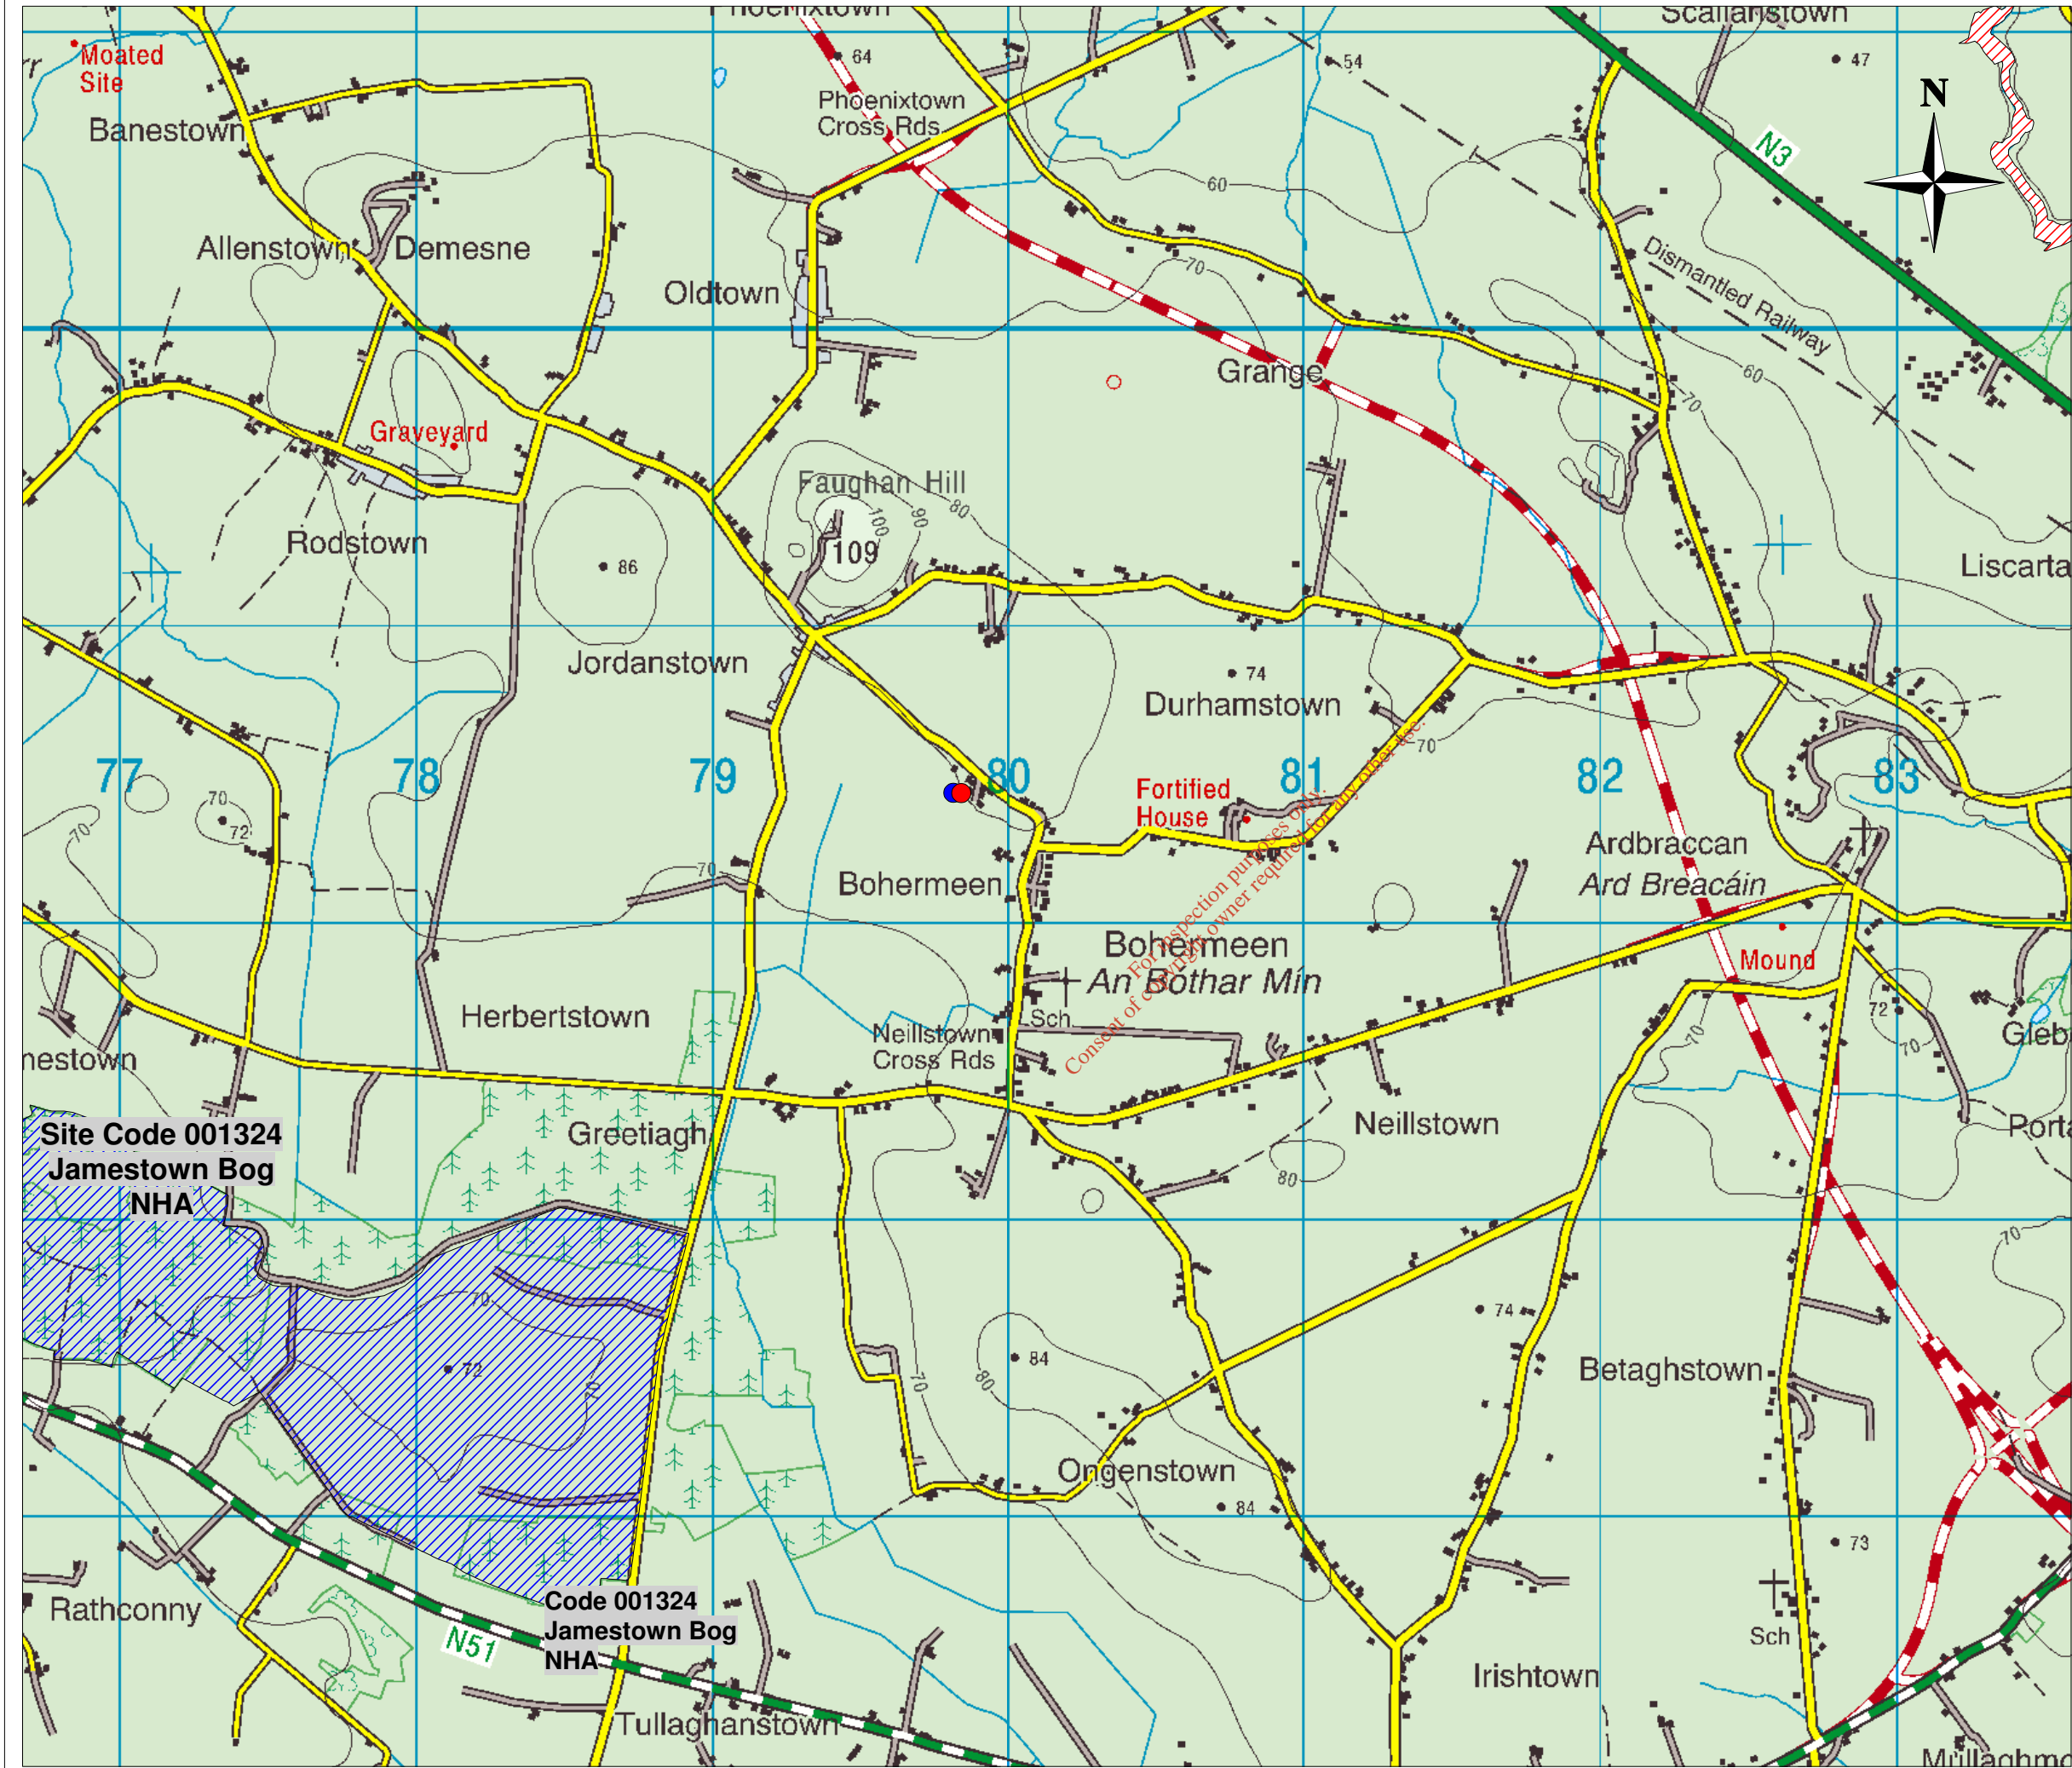

NOTES

Figured dimensions only to be taken from this drawing
All dimensions to be checked on site.

All Levels are in Metres and Relate to O.S. Datum Malin
All Maps are Referenced to Irish National Grid (I.N.G.)

Ordnance Survey of Ireland Licence No.EN 0002609
© Government of Ireland

Key Map Features


- Waste Water Treatment Plant
- Primary Discharge Point
- pNHA / NHA
- SAC
- SPA

Rev:	Description:	Drawn:	Ch'kd:	Date:

Client:

MEATH COUNTY COUNCIL

Client Representative:



JENNINGS O'DONOVAN
CONSULTING ENGINEERS

Project:

**Waste Water Discharge
Certificate Authorisation**

Drawing Title:

**Bohermeen
Attachment F.1
Designation Map**

Drawn By:	T.C	Date:	December 09
Checked By:	Y.McM	Date:	December 09
Stage:	Waste Water Discharge Certificate		
Scales:	N.T.S.		
Drawing No.	4654/OL/05/06	Revision:	